


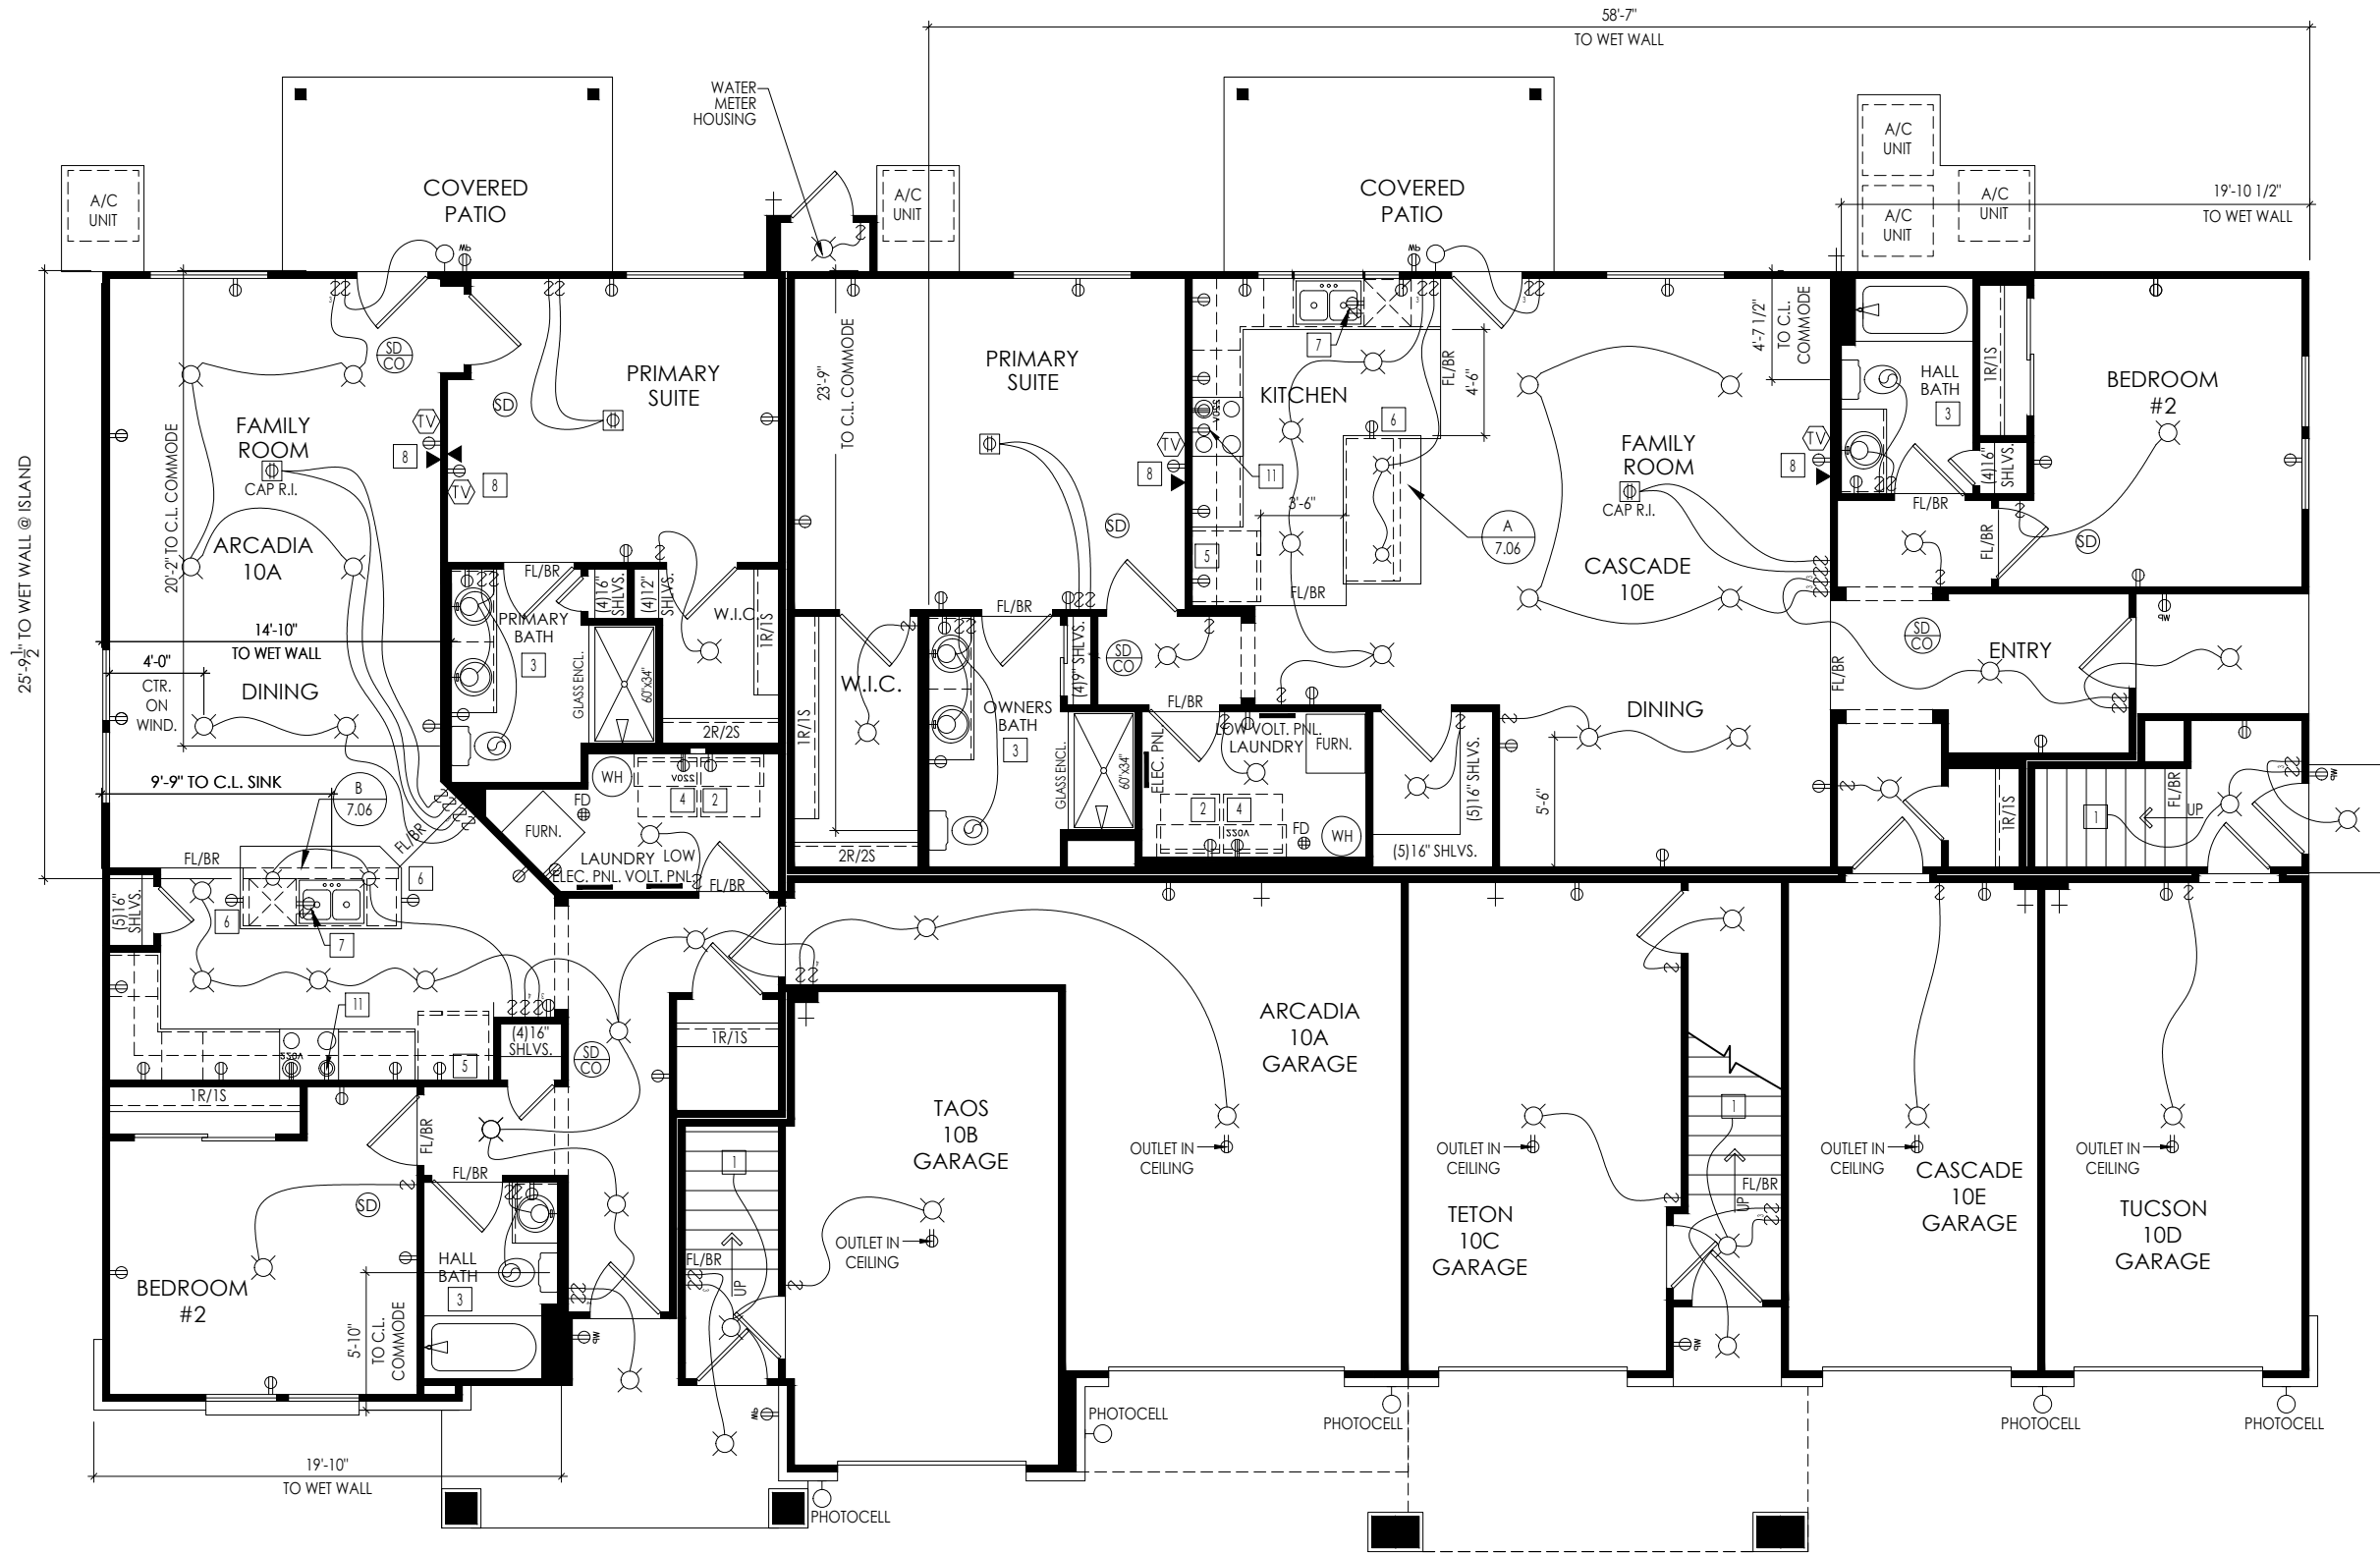

General Notes

1. REFER TO SHEET ON.1 FOR GENERAL NOTES.
2. SEE SHEET 4.01 FHA FOR ALL FAIR HOUSING ACT COMPLIANCE INSTRUCTIONS.
3. ALL TUB AND SHOWER CONTROLS TO BE WALL MOUNTED.

Key Notes

- 1 TO LIGHT/SWITCH ABOVE
- 2 WASHER TO THE LEFT OF DRYER, ALL INSTANCES.
- 3 SEE SHEET 4.01 FHA FOR ADDITIONAL DETAILS.
- 4 5'-0" L x 16" D SHELF @ 5'-7" A.F.F.
- 5 ALLOW 3'-3" FOR FINISHED CABINET SPACE
- 6 OUTLET HELD HIGH
- 7 PLACE OUTLET FOR DISHWASHER & SWITCH FOR DISPOSAL IN SINK CABINET
- 8 OUTLET & JACK TO BE HELD 66" A.F.F.
- 9 -
- 10 -
- 11 OUTLET FOR MICROWAVE/ RANGE HOOD.
- 12 -
- 13 -
- 14 -

Mechanical Legend

DATA JACK	FLUORESCENT LIGHT
WALL OUTLET	UNDER CABINET LIGHTING
WEATHERPROOF OUTLET	CLG. MOUNTED LIGHT FIXT.
220 OUTLET	WALL MOUNTED LIGHT FIXT.
GROUND FAULT CIRCUIT INTERRUPT OUTLET	SURFACE MOUNT DISC LIGHT OR RECESSED CEILING LIGHT, PER SPECS.
FLOOR OUTLET	DOUBLE SPOTLIGHT FIXT.
CABLE TELEVISION JACK	DIRECTIONAL CAN LIGHT
SINGLE POLE SWITCH	PIN LIGHT
3-WAY SWITCH	WALL SCONCE @ 5'-6" A.F.F.
4-WAY SWITCH	STAIR LIGHT
SMOKE DETECTOR	CLG. MTD. EXHAUST FAN
SMOKE DETECTOR/ CO DETECTOR COMBINATION	WALL MTD. EXHAUST FAN
BLOCK, MOUNT, & SWITCH FOR FUTURE FAN/LIGHT COMBINATION (CENTER, UNLESS OTHERWISE NOTED)	SHOWER HEAD
EXHAUST FAN AND LIGHT COMBINATION	HOSE BIB
FLOOR DRAIN	GAS HOOK UP

RESIDENCE FOR:

MARKET

**337 - 321 CORNWALL DRIVE
AVALON**


Job Number:	Drawing Date:	Coord Name:	Coord Phone:
ANVA-0010S-00	03/11/24	L. RAMLER	859.578.4212
House Name:	Drawing Scale: 1/8" = 1'-0"	Drawn By:	
the CLASSIC IV		AKS	
		Series:	CLASSIC



Sheet Information

4.01

FIRST FLOOR MECHANICAL PLAN
ELEVATION "A"

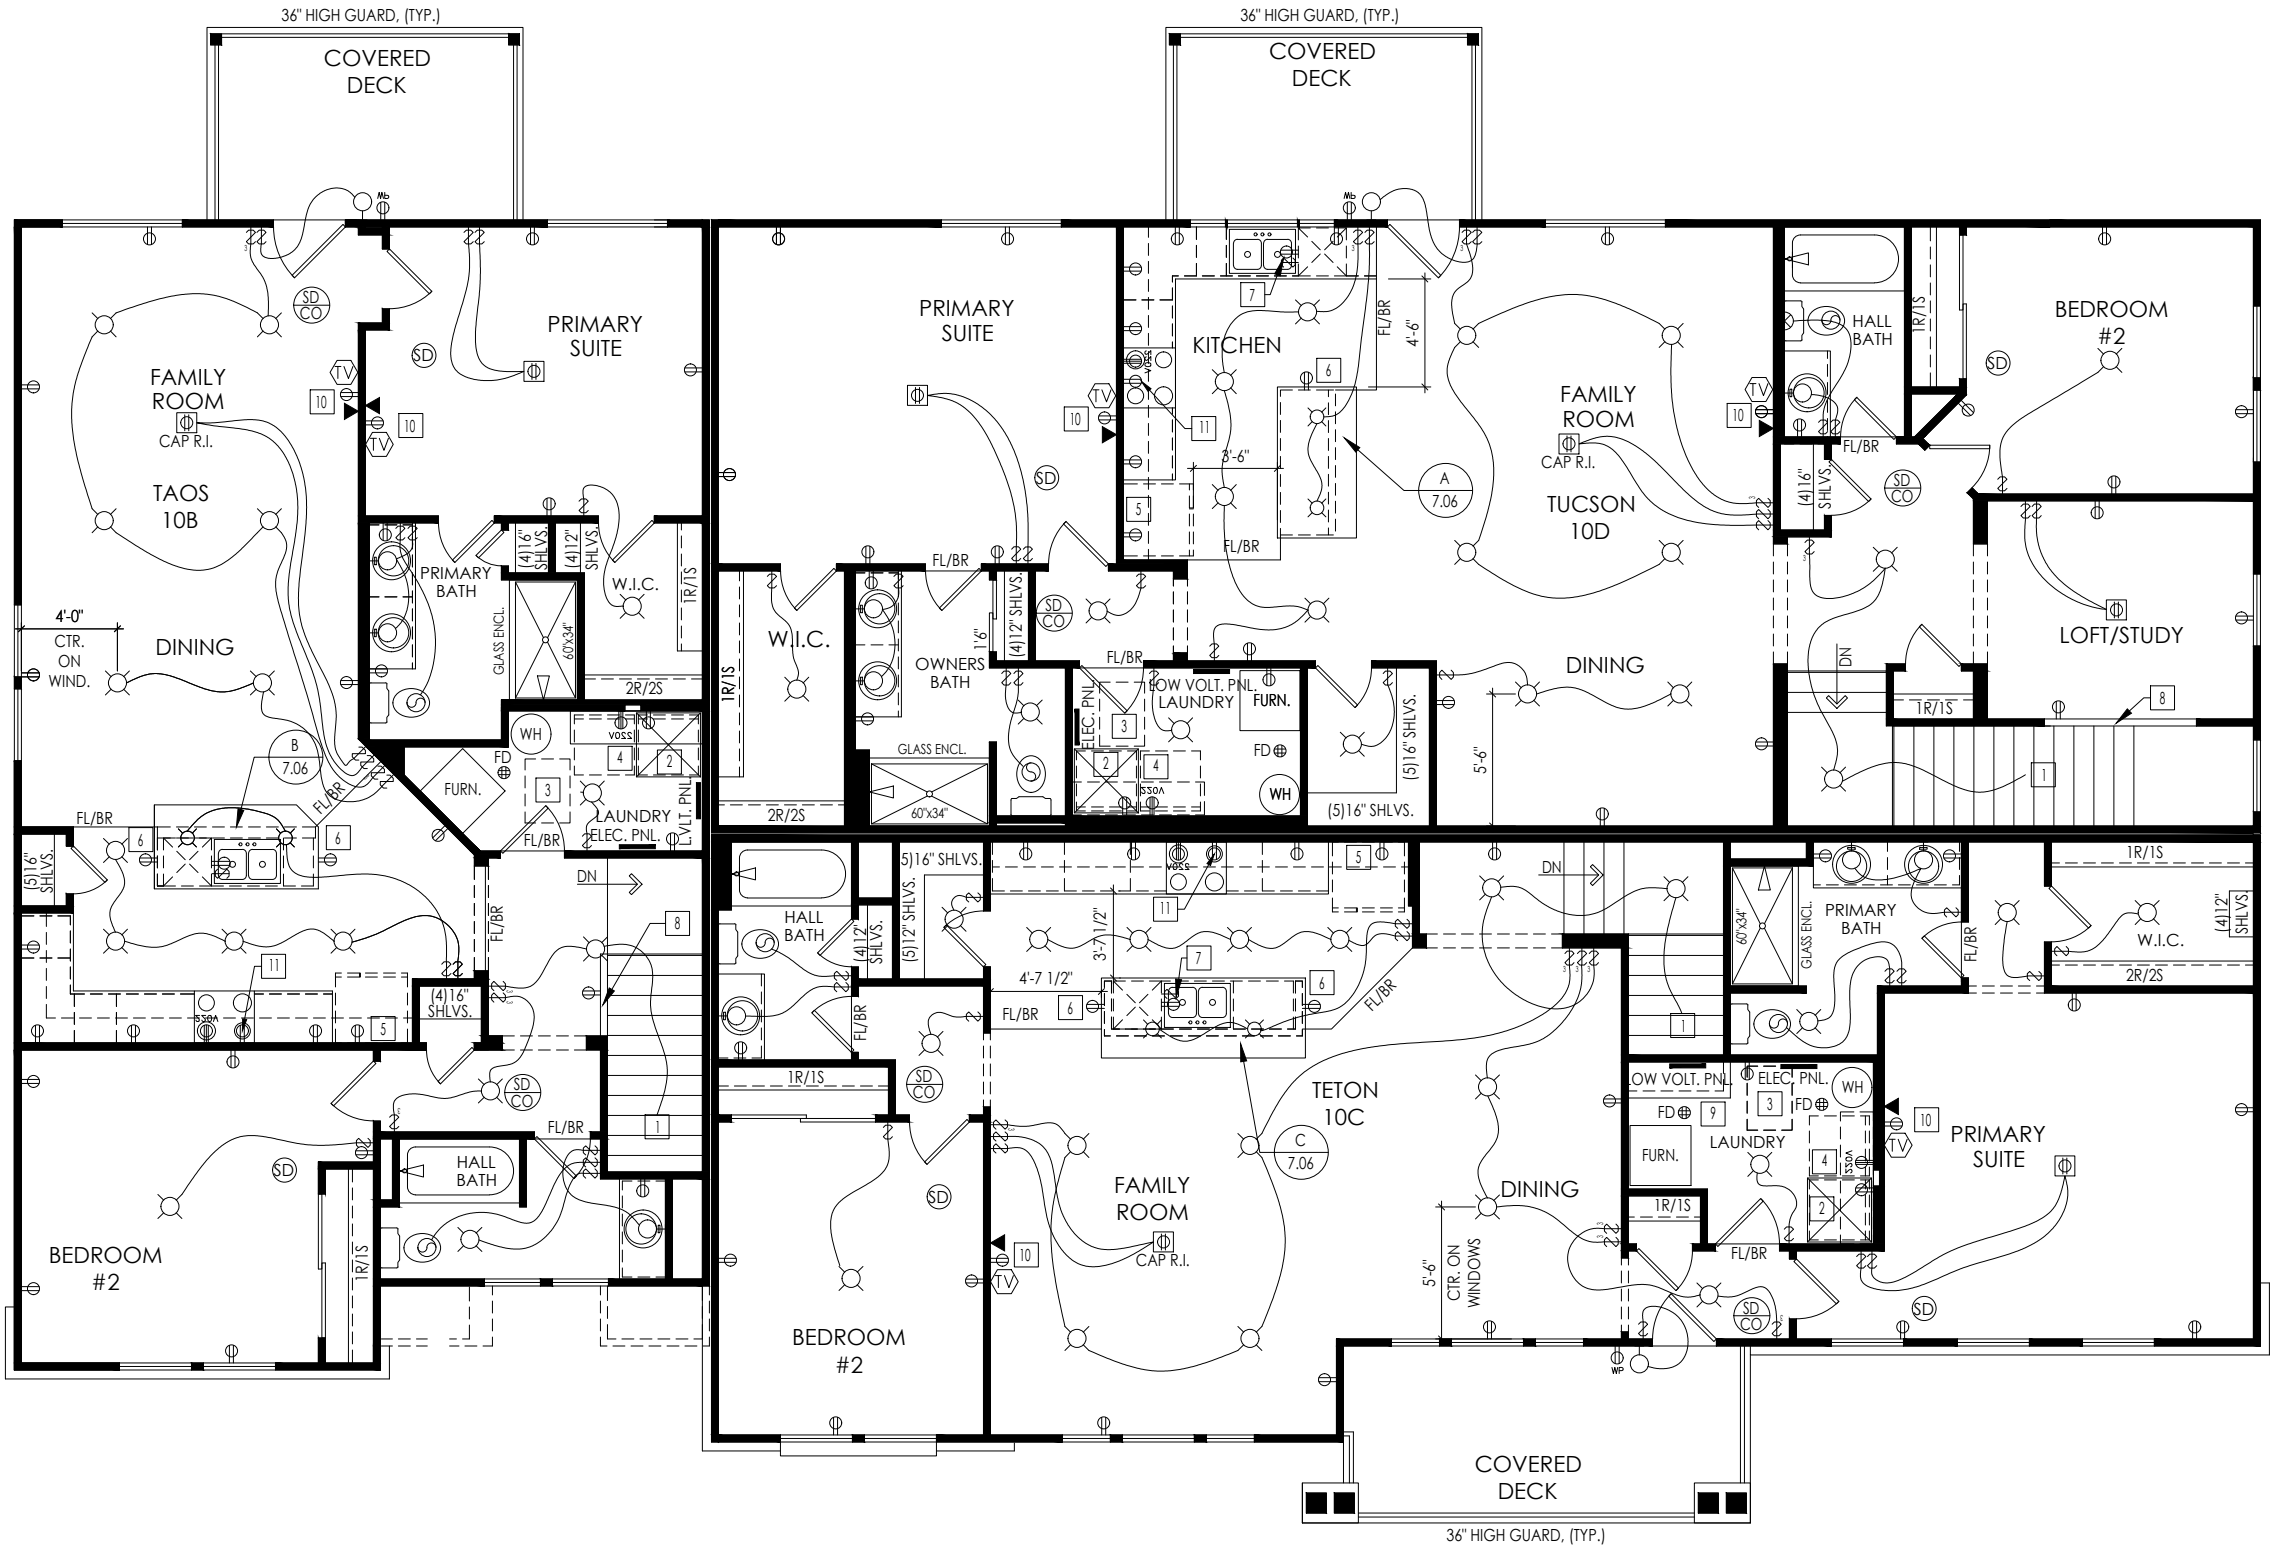

- General Notes**
1. REFER TO SHEET ON.1 FOR GENERAL NOTES.
 2. ALL TUB AND SHOWER CONTROLS TO BE WALL MOUNTED.
- Key Notes**
- 1 TO LIGHT/SWITCH BELOW
 - 2 WASHER TO THE LEFT OF DRYER, ALL INSTANCES. PROVIDE WASHER PAN ON 2ND FLOOR.
 - 3 22-1/2"x 32" ATTIC ACCESS PANEL
 - 4 5'-0" L x 16" D SHELF @ 5'-7" A.F.F.
 - 5 ALLOW 3'-3" FOR FINISHED CABINET SPACE
 - 6 OUTLET HELD HIGH
 - 7 PLACE OUTLET FOR DISHWASHER & SWITCH FOR DISPOSAL IN SINK CABINET
 - 8 WOOD CAP @ HALF WALL
 - 9 COVER PLATFORM WITH WOOD CAP
 - 10 OUTLET & JACK TO BE HELD 66" A.F.F.
 - 11 OUTLET FOR MICROWAVE/ RANGE HOOD.
 - 12 --

Mechanical Legend	
- DATA JACK - WALL OUTLET - WEATHERPROOF OUTLET 220 OUTLET - GROUND FAULT CIRCUIT INTERRUPT OUTLET - FLOOR OUTLET - CABLE TELEVISION JACK - SINGLE POLE SWITCH 3-WAY SWITCH 4-WAY SWITCH - SMOKE DETECTOR - SMOKE DETECTOR/ CO DETECTOR COMBINATION - BLOCK, MOUNT, & SWITCH FOR FUTURE FAN/LIGHT COMBINATION (CENTER, UNLESS OTHERWISE NOTED) - EXHAUST FAN AND LIGHT COMBINATION - FLOOR DRAIN	- FLUORESCENT LIGHT - UNDER CABINET LIGHTING - CLG. MOUNTED LIGHT FIXT. - WALL MOUNTED LIGHT FIXT. - SURFACE MOUNT DISC LIGHT OR RECESSED CEILING LIGHT, PER SPECS. - DOUBLE SPOTLIGHT FIXT. - DIRECTIONAL CAN LIGHT - PIN LIGHT - WALL SCONCE @ 5'-6" A.F.F. - STAIR LIGHT - CLG. MTD. EXHAUST FAN - WALL MTD. EXHAUST FAN - SHOWER HEAD - HOSE BIB - GAS - GAS HOOK UP

RESIDENCE FOR:

MARKET

337 - 321 CORNWALL DRIVE

AVALON

Job Number:	Drawing Date:	Coord Name:	Coord Phone:
ANVA-0010S-00	03/11/24	L. RAMLER	859.578.4212
House Name:	Drawing Scale: 1/8" = 1'-0"	Drawn By:	
the CLASSIC IV		AKS	
		Series:	CLASSIC

Drees

HOMESSM

Copyright © 1998, (2019) The Drees Company, All Rights Reserved.
211 GRANDVIEW DRIVE, FORT MITCHELL, KY 41017
PHONE: (859) 578-4200

Sheet Information

4.02

2ND FLOOR MECHANICAL PLAN

ELEVATION "A"



REAR ELEVATION

6.01

FRONT & REAR ELEVATIONS

ELEVATION "A"