


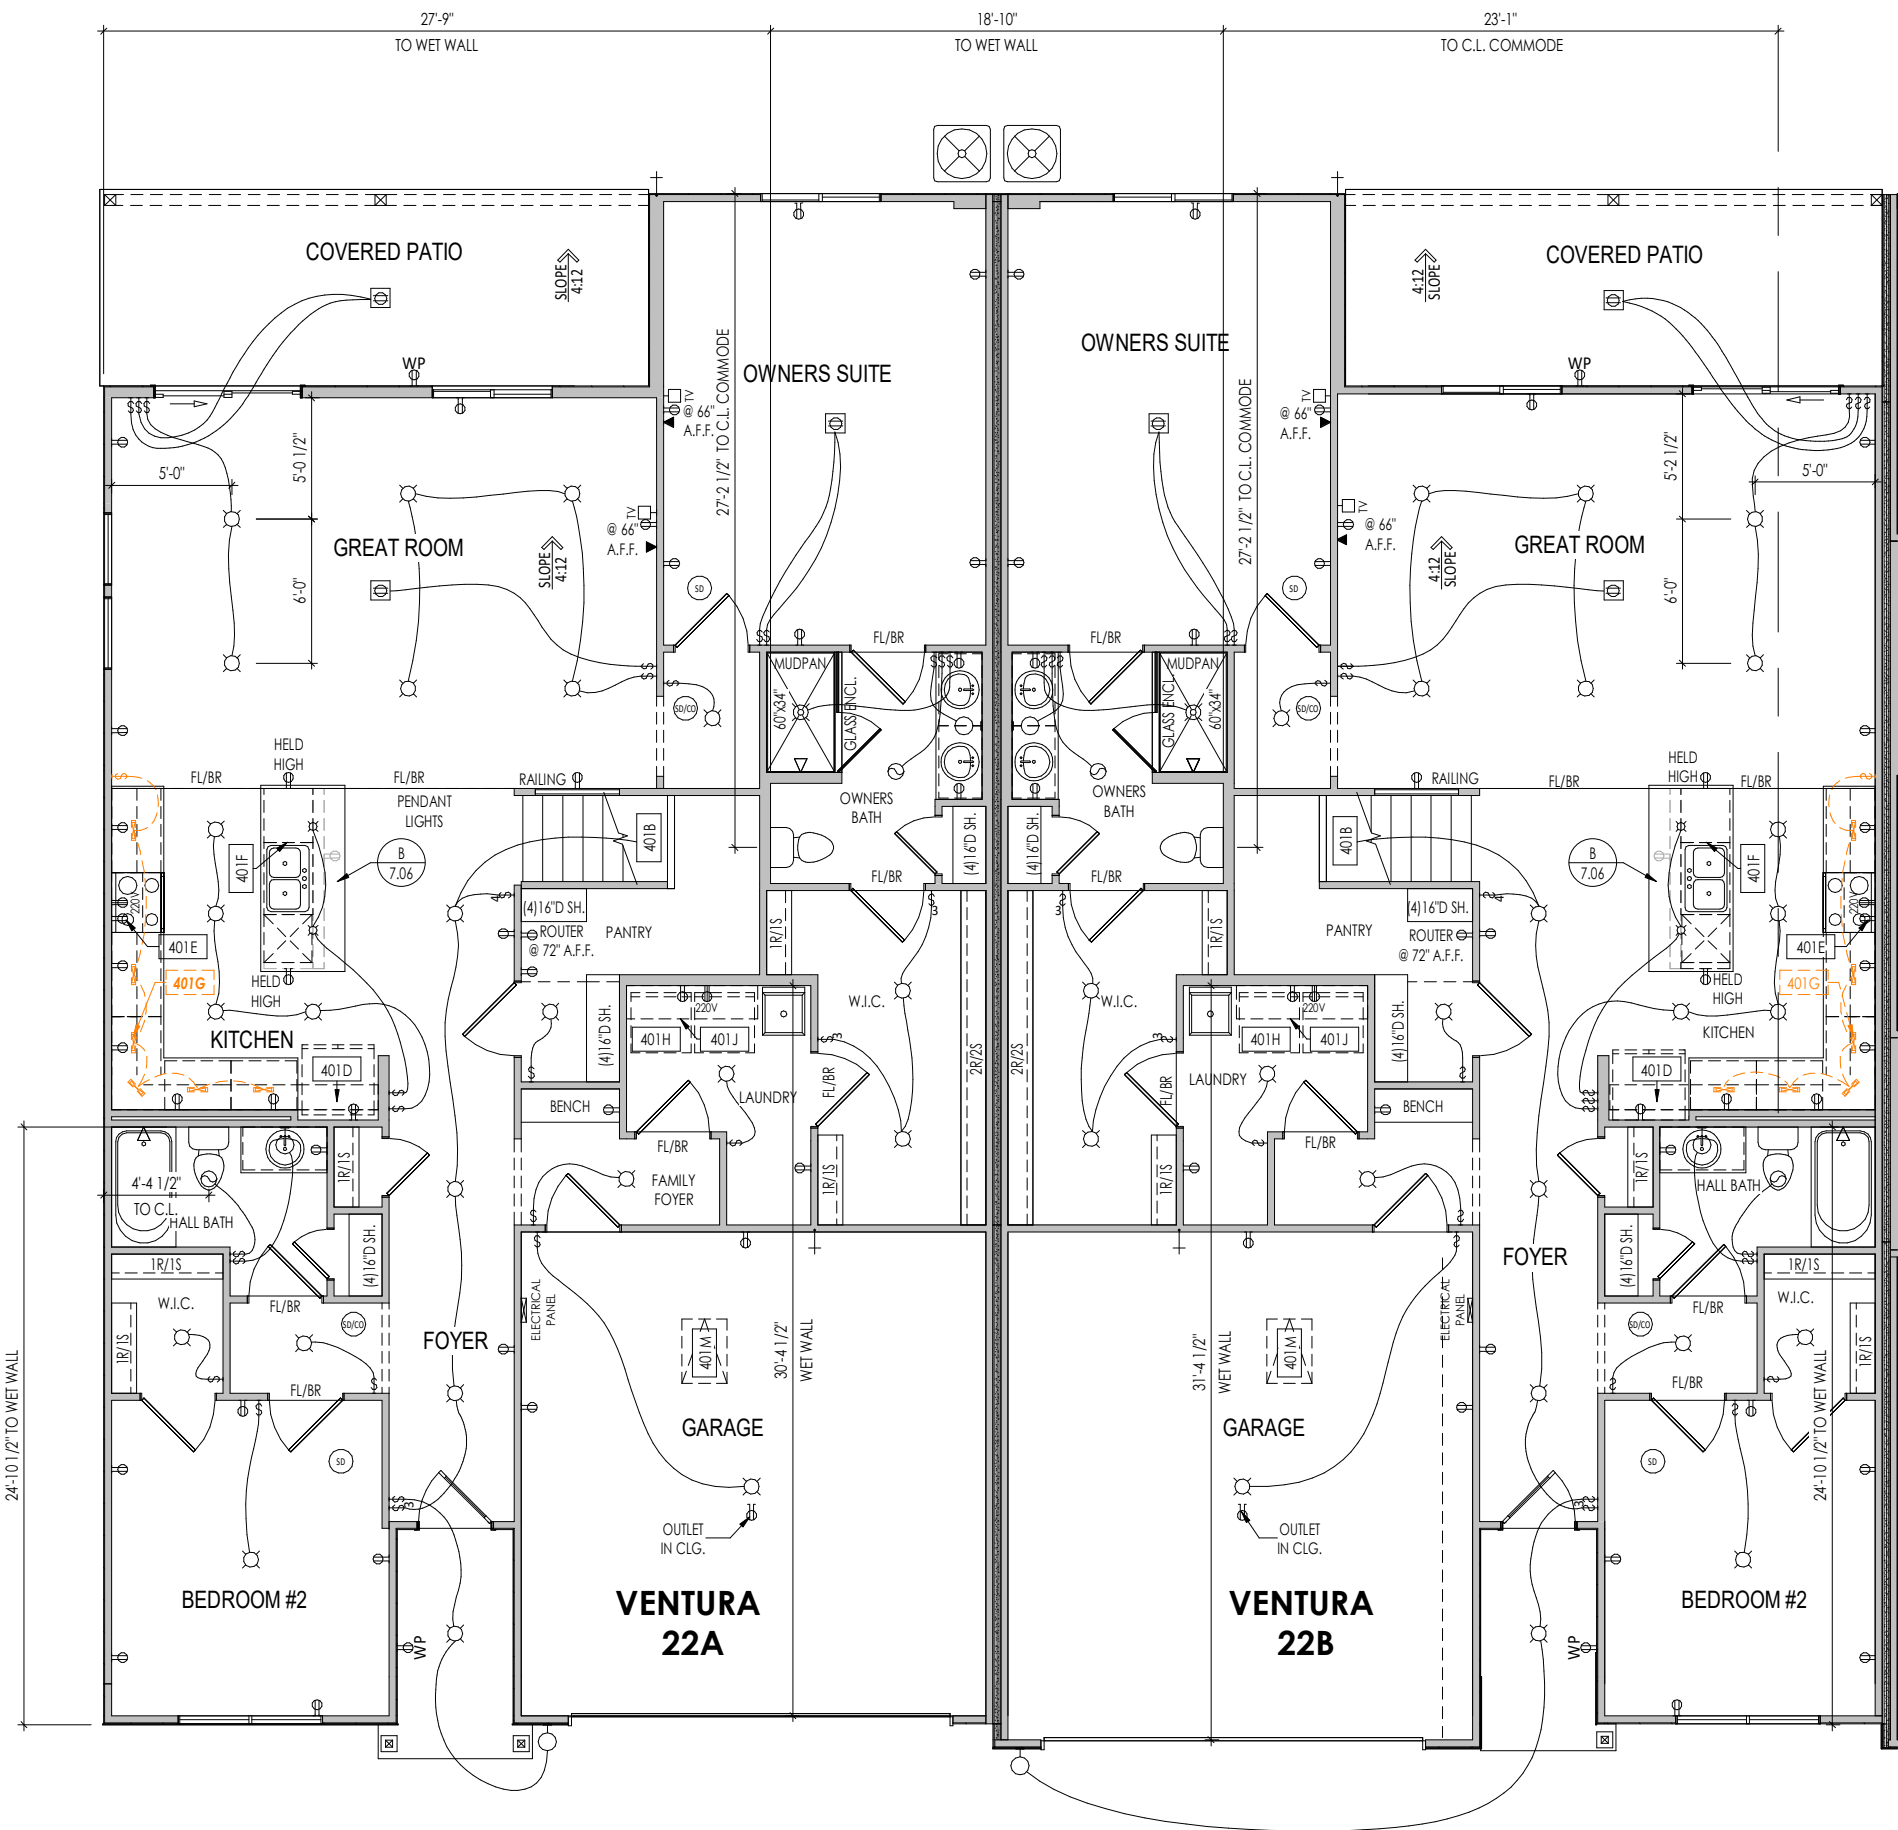

General Notes:

1. REFER TO SHEET ON.1 FOR GENERAL NOTES.

Key Notes:

401B	TO SWITCH OR LIGHT ABOVE
401D	ALLOW 3'-3" FOR CABINET OVER REFRIGERATOR SPACE
401E	OUTLET FOR RANGE HOOD/MICROWAVE HELD HIGH - DO NOT VENT TO EXTERIOR
401F	OUTLET FOR DISHWASHER & DISPOSAL SWITCH LOCATED IN SINK CABINET
401G	LOCATION OF OPTIONAL UNDER COUNTER LIGHTS, REFER TO SELECTIONS.
401H	LOCATE WASHER TO LEFT OF DRYER
401J	16"D SHELF HELD AT 5'-7" A.F.F.
401M	22-1/2" x 32" ATTIC ACCESS PANEL

MECHANICAL LEGEND

◀ DATA JACK	⊗ CLG. MOUNTED LIGHT FIXT.	■ STAIR LIGHT
⊕ WALL OUTLET	○ SURFACE MOUNT DISC LIGHT OR RECESSED CEILING LIGHT, PER SPECS.	+ HOSE BIB
⊕ WEATHERPROOF OUTLET	○ WALL MOUNTED LIGHT FIXT.	△ SHOWER HEAD
⊕ 220 VOLT OUTLET	⊕ DOUBLE SPOTLIGHT FIXT.	⊕ GAS GAS HOOK UP
⊕ GROUND FAULT OUTLET	⊕ DIRECTIONAL CAN LIGHT	⊕ FLOOR DRAIN
⊕ FLOOR OUTLET	⊕ PIN LIGHT	⊕ SMOKE DETECTOR
⊕ CABLE TELEVISION JACK	⊕ WALL SCONCE @ 5'-6" A.F.F.	⊕ CO DETECTOR
⊕ SINGLE POLE SWITCH	⊕ FLUORESCENT LIGHT	⊕ SMOKE DETECTOR/CO DETECTOR COMBINATION
⊕ 3-WAY SWITCH	⊕ UNDER CABINET LIGHTING	⊕ EXHAUST FAN AND LIGHT COMBINATION
⊕ 4-WAY SWITCH		⊕ CLG. MTD. EXHAUST FAN
⊕ BLOCK, MOUNT, & SWITCH FOR FUTURE FAN/LIGHT COMBINATION (CENTER, UNLESS OTHERWISE NOTED)		

RESIDENCE FOR:

MARKET

4339 - 4343 WINDEMERE CIRCLE

BILLINGSLEY RETREAT


Job Number:	Drawing Date:	Coord Name:	Coord Phone:
BILT-0022S-00	06.29.23	L. RAMLER	859.578.4212
House Name:	Drawing Scale: 1/8" = 1'0"	Contract Drawn By:	
Ventura, Ventura, + Calabasas II 3-Unit Bldg.		AKS	
		Series:	
		Plan No.:	
Born on Date:	04/05/2020	CDs Drawn By:	ALD

Drees HOMES
SM
Copyright © 2018 (2022) The Drees Company. All Rights Reserved.
211 Grandview Drive, Fort Mitchell, KY 41017
Phone: [859] 578-4200

Sheet Information

4.01.0

First Floor Mechanical Plan
Elevation 'A'

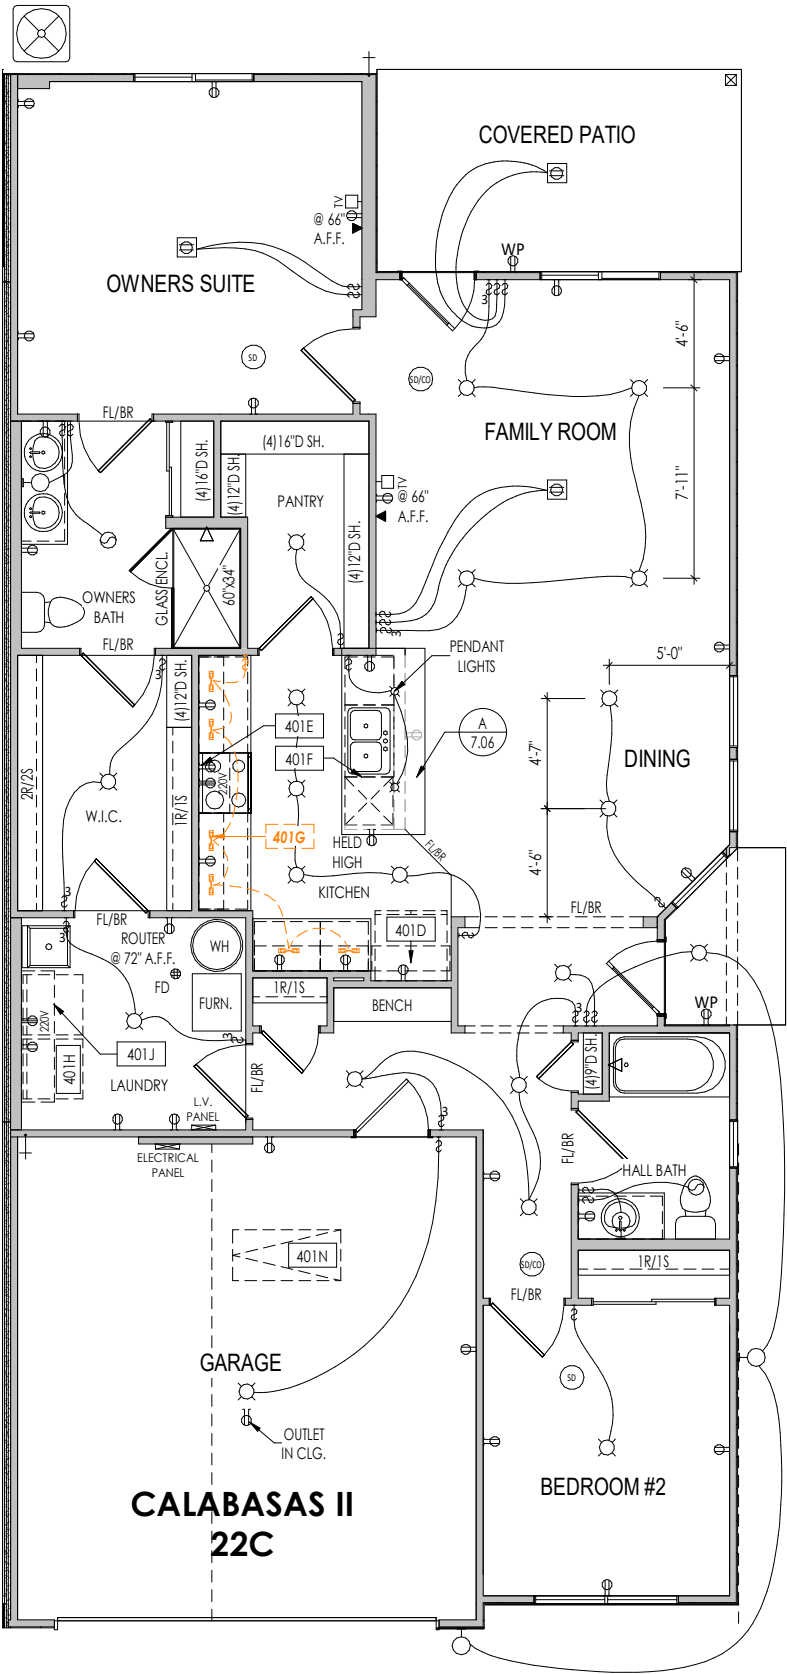

General Notes:	
1. REFER TO SHEET ON.1 FOR GENERAL NOTES.	
Key Notes:	
401D	ALLOW 3'-3" FOR CABINET OVER REFRIGERATOR SPACE
401E	OUTLET FOR RANGE HOOD/MICROWAVE HELD HIGH - DO NOT VENT TO EXTERIOR
401F	OUTLET FOR DISHWASHER & DISPOSAL SWITCH LOCATED IN SINK CABINET
401G	LOCATION OF OPTIONAL UNDER COUNTER LIGHTS. REFER TO SELECTIONS.
401H	LOCATE WASHER TO LEFT OF DRYER
401J	16"D SHELF HELD AT 5'-7" A.F.F.
401N	PULL DOWN ATTIC ACCESS STAIRS (25-1/2" x 54") WITH LIGHT AND OUTLET

MECHANICAL LEGEND		
◀ DATA JACK	⊗ CLG. MOUNTED LIGHT FIXT.	■ STAIR LIGHT
⊕ WALL OUTLET	○ SURFACE MOUNT DISC LIGHT OR RECESSED CEILING LIGHT, PER SPECS.	+ HOSE BIB
⊕ WEATHERPROOF OUTLET	○ WALL MOUNTED LIGHT FIXT.	△ SHOWER HEAD
⊕ 220 VOLT OUTLET	⊕ DOUBLE SPOTLIGHT FIXT.	⊕ GAS GAS HOOK UP
⊕ GROUND FAULT OUTLET	⊕ DIRECTIONAL CAN LIGHT	⊕ FLOOR DRAIN
⊕ FLOOR OUTLET	⊕ PIN LIGHT	⊕ SMOKE DETECTOR
⊕ CABLE TELEVISION JACK	⊕ WALL SCONCE @ 5'-6" A.F.F.	⊕ CO DETECTOR
↔ SINGLE POLE SWITCH	⊕ FLUORESCENT LIGHT	⊕ SMOKE DETECTOR/CO DETECTOR COMBINATION
↔ 3-WAY SWITCH	⊕ UNDER CABINET LIGHTING	⊕ EXHAUST FAN AND LIGHT COMBINATION
↔ 4-WAY SWITCH		⊕ CLG. MTD. EXHAUST FAN
⊕ BLOCK, MOUNT, & SWITCH FOR FUTURE FAN/LIGHT COMBINATION (CENTER, UNLESS OTHERWISE NOTED)		

Space for Architect Seal


RESIDENCE FOR: MARKET 4339 - 4343 WINDEMERE CIRCLE BILLINGSLEY RETREAT			
Job Number: BILT-0022S-00	Drawing Date: 06.29.23	Coord Name: L. RAMLER	Coord Phone: 859.578.4212
House Name: Ventura, Ventura, + Calabasas II 3-Unit Bldg.			Contract Drawn By: AKS
Drawing Scale: 1/8" = 1'0"			Series:
Born on Date: 04/05/2020			Plan No.:
CDs Drawn By: ALD			



Copyright © 2018 (2022) The Drees Company. All Rights Reserved.
211 Grandview Drive, Fort Mitchell, KY 41017
Phone: [859] 578-4200

Sheet Information

4.01.1
First Floor Mechanical Plan
Elevation 'A'

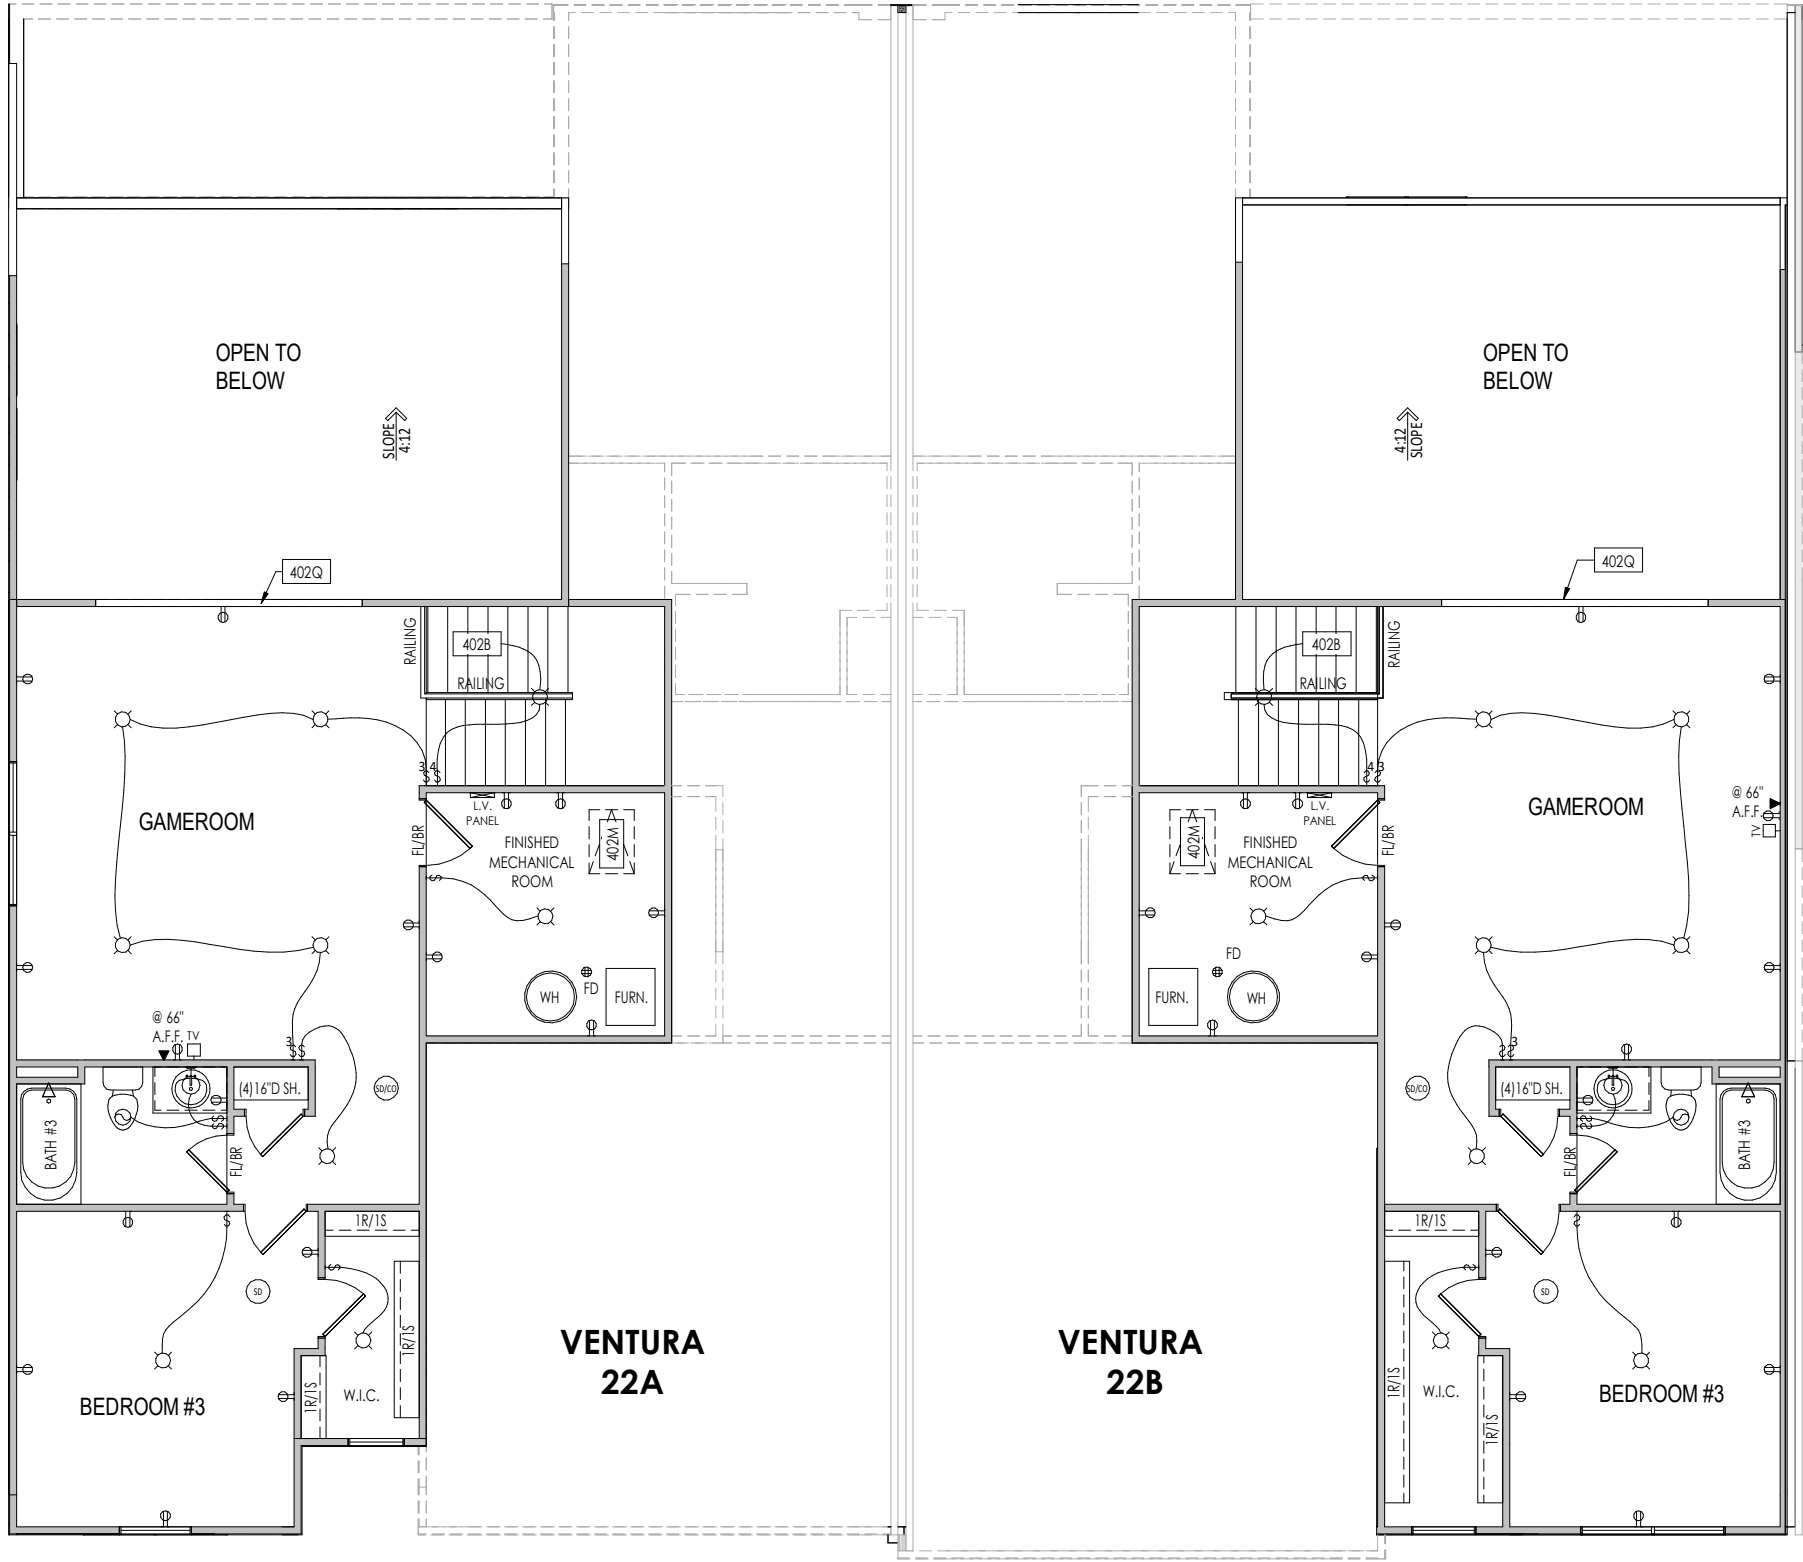

General Notes:		
1. REFER TO SHEET ON.1 FOR GENERAL NOTES.		
Key Notes:		
402B	TO SWITCH OR LIGHT BELOW	
402M	22-1/2" x 32" ATTIC ACCESS PANEL	
402Q	HALF WALL w/ WOOD CAP	
MECHANICAL LEGEND		
◀ DATA JACK	☉ CLG. MOUNTED LIGHT FIXT.	■ STAIR LIGHT
⊕ WALL OUTLET	○ SURFACE MOUNT DISC LIGHT OR RECESSED CEILING LIGHT, PER SPECS.	+ HOSE BIB
⊕ WEATHERPROOF OUTLET	○ WALL MOUNTED LIGHT FIXT.	△ SHOWER HEAD
⊕ 220 VOLT OUTLET	⊕ DOUBLE SPOTLIGHT FIXT.	⊕ GAS GAS HOOK UP
⊕ GROUND FAULT OUTLET	⊕ DIRECTIONAL CAN LIGHT	⊕ FLOOR DRAIN
⊕ FLOOR OUTLET	⊕ PIN LIGHT	⊕ SMOKE DETECTOR
⊕ CABLE TELEVISION JACK	⊕ WALL SCONCE @ 5'-6" A.F.F.	⊕ CO DETECTOR
↔ SINGLE POLE SWITCH	⊕ FLUORESCENT LIGHT	⊕ SMOKE DETECTOR/ CO DETECTOR COMBINATION
↔ 3-WAY SWITCH	⊕ UNDER CABINET LIGHTING	⊕ EXHAUST FAN AND LIGHT COMBINATION
↔ 4-WAY SWITCH	⊕ BLOCK, MOUNT, & SWITCH FOR FUTURE FAN/LIGHT COMBINATION (CENTER, UNLESS OTHERWISE NOTED)	⊕ CLG. MTD. EXHAUST FAN

RESIDENCE FOR:
MARKET
4339 - 4343 WINDEMERE CIRCLE
BILLINGSLEY RETREAT

Job Number: BILT-0022S-00	Drawing Date: 06.29.23	Coord Name: L. RAMLER	Coord Phone: 859.578.4212
House Name: Ventura, Ventura, + Calabasas II 3-Unit Bldg.			Contract Drawn By: AKS
Born on Date: 04/05/2020			CDs Drawn By: ALD




Sheet Information

4.02

2nd Floor Mechanical Plan
Elevation 'A'

TYPICAL TRIM:
6" FASCIA (ALL SIDES)
8" FRIEZE (FRONT ONLY, UNLESS OTHERWISE NOTED)

General Notes:	
1. REFER TO SHEET 00.1 FOR GENERAL NOTES. 2. ROOFING MATERIAL PER SELECTIONS. 3. CONTACT M&K ENGINEERING FOR HEADER SIZE/BRICK SUPPORT IF GRADE DROPS AND THE AMOUNT OF BRICK OVER GARAGE DOOR SHOWN ON CURRENT ELEVATION IS NO LONGER ACCURATE	
Key Notes:	
601B	STONE WATERTABLE TO WRAP BACK 2'-0" FROM CORNER
601C	STONE WATERTABLE TO WRAP BACK 3'-0" FROM CORNER

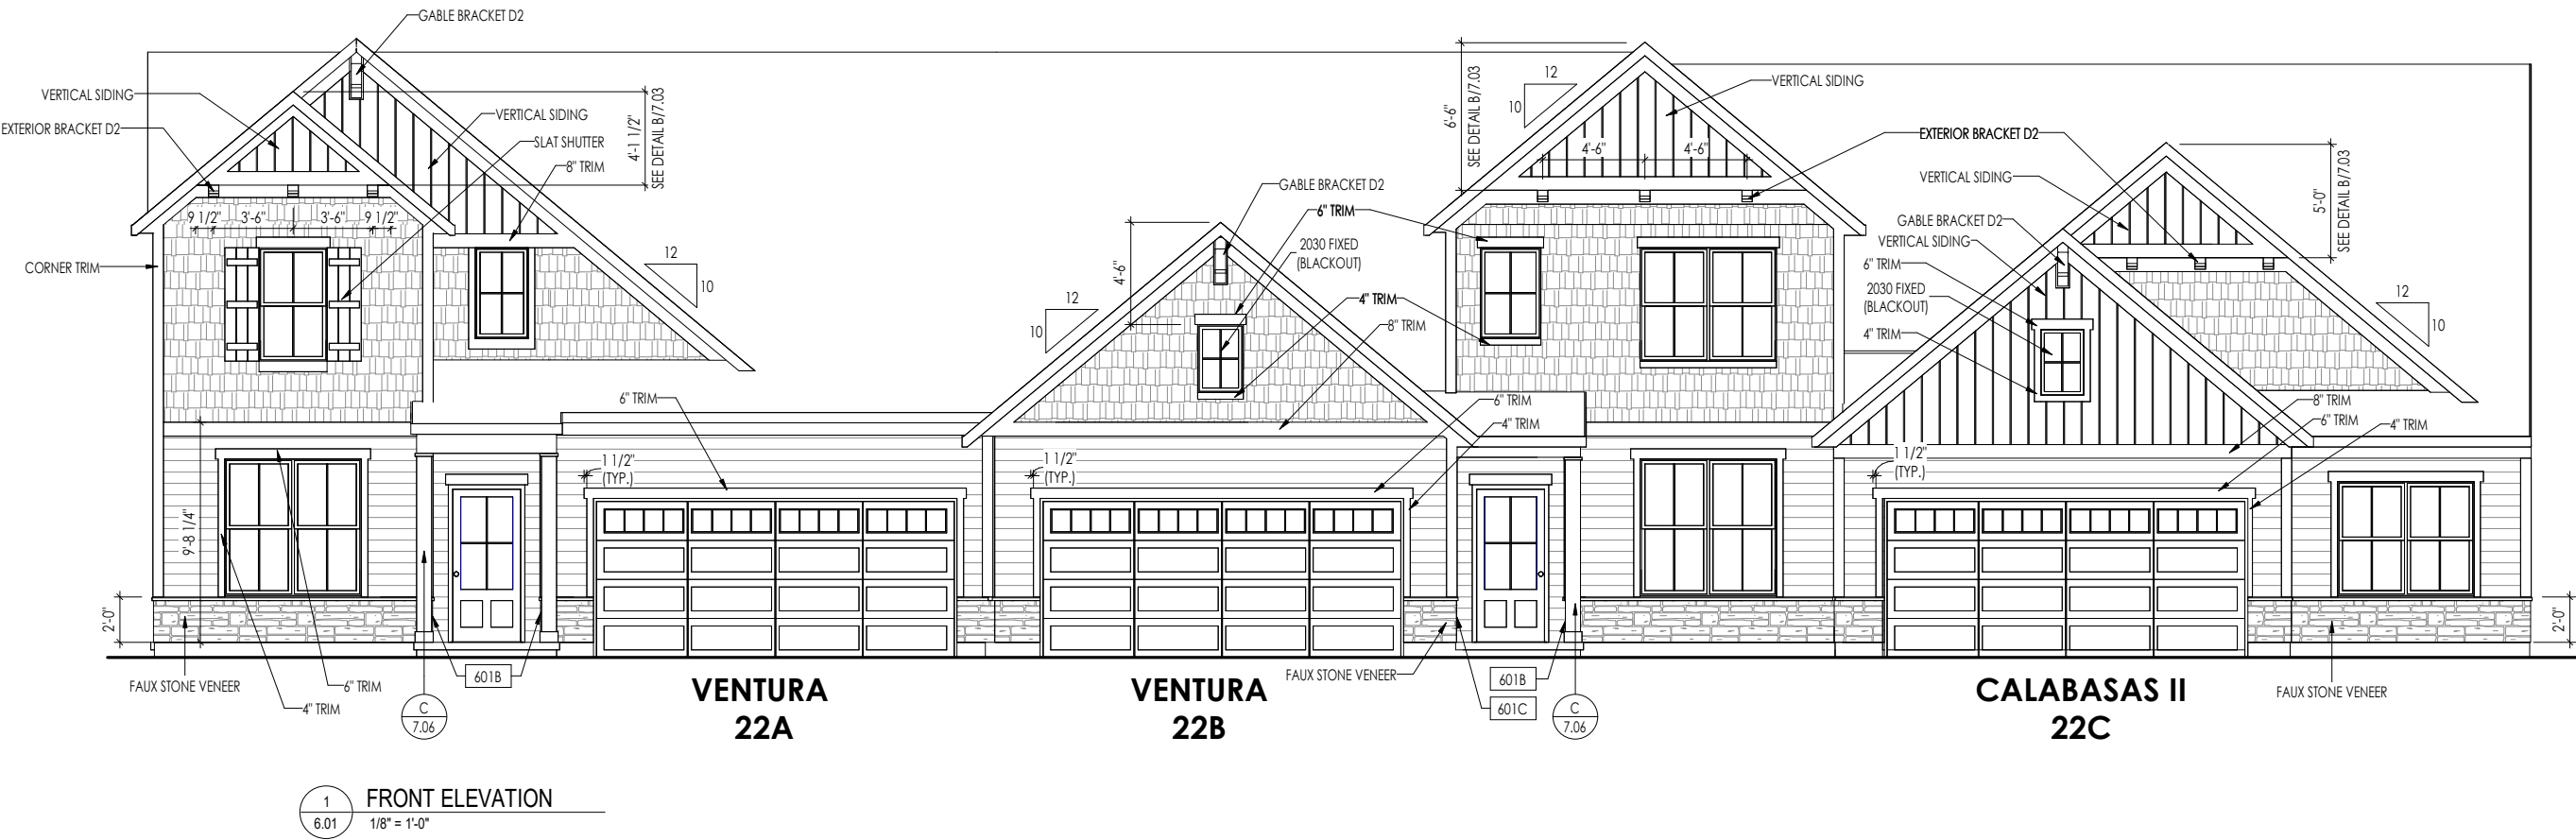

RESIDENCE FOR: MARKET 4339 - 4343 WINDEMERE CIRCLE BILLINGSLEY RETREAT			
Job Number: BILT-0022S-00	Drawing Date: 06.29.23	Coord Name: L. RAMLER	Coord Phone: 859.578.4212
House Name: Ventura, Ventura, + Calabasas II 3-Unit Bldg.			Contract Drawn By: AKS
Born on Date: 04/05/2020			Series:
CDs Drawn By: ALD			Plan No.:
Drees HOMES SM Copyright © 2018 (2022) The Drees Company. All Rights Reserved. 211 Grandview Drive, Fort Mitchell, KY 41017 Phone: [859] 578-4200			6.01 Front Elevations Elevation 'A'