


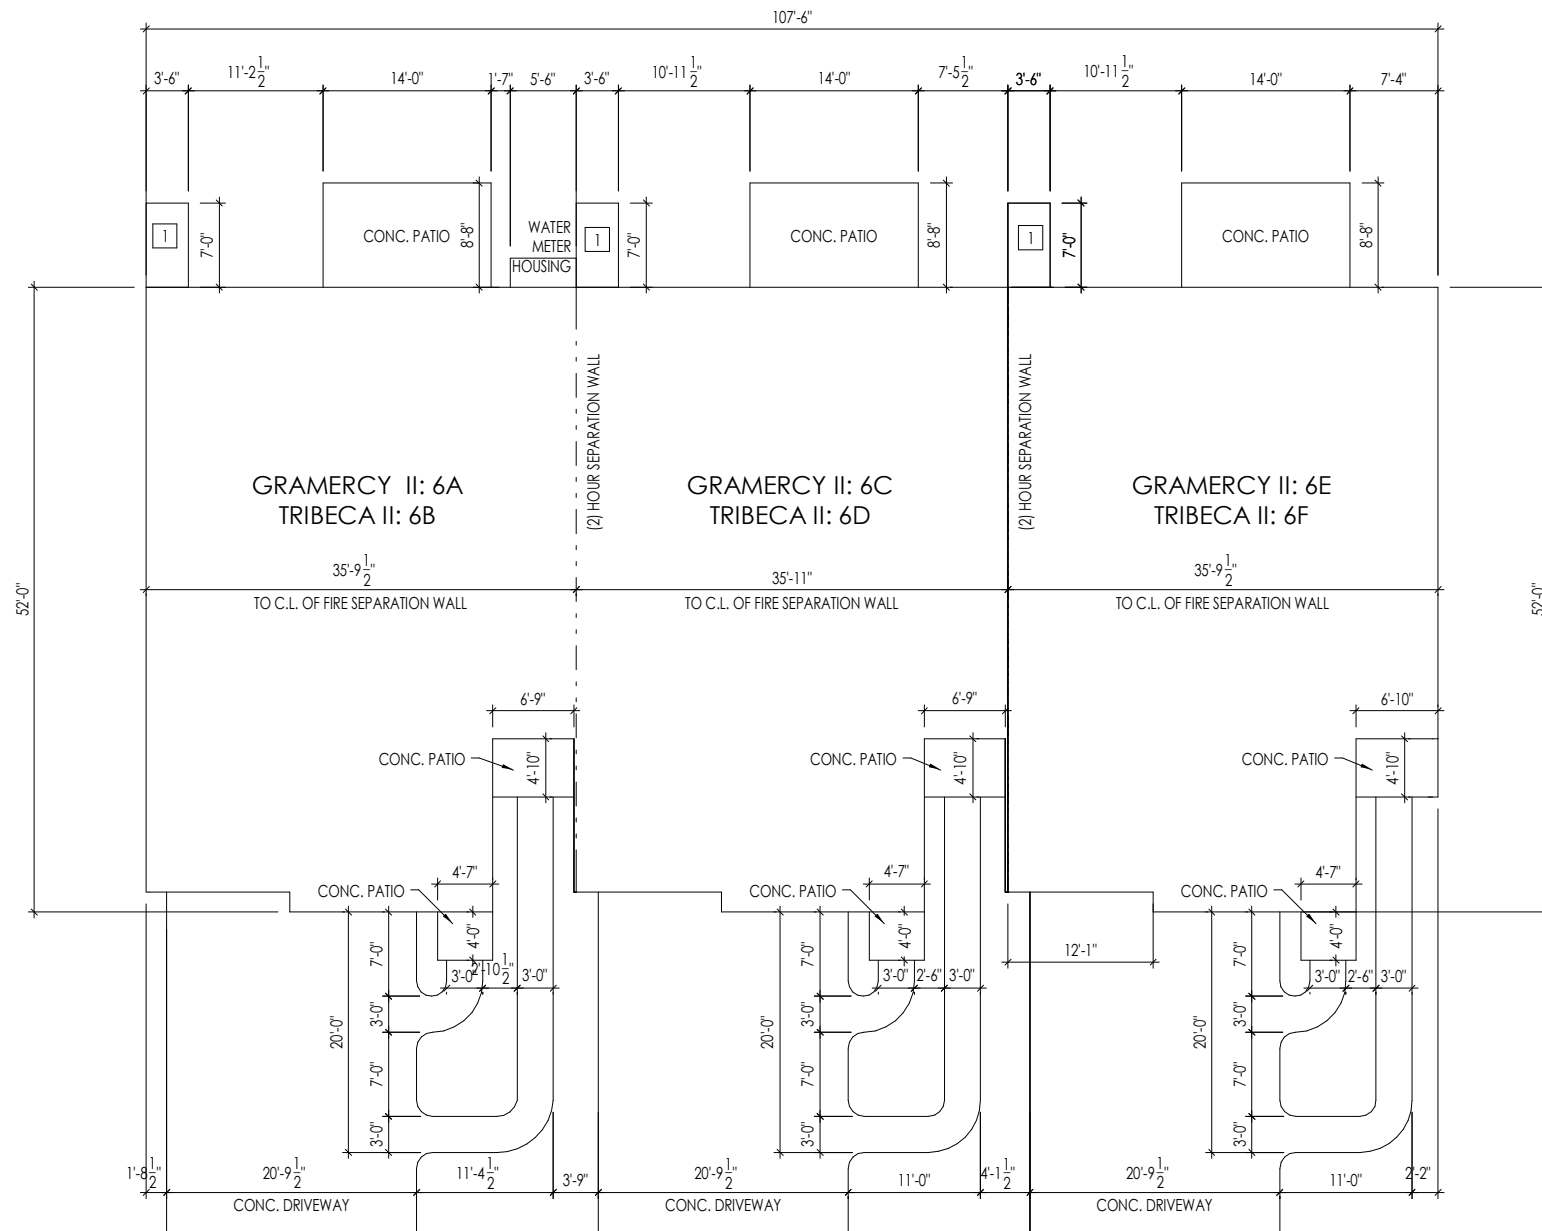

OVERALL BUILDING PLAN

SCALE: 1/16" = 1'-0"

RESIDENCE FOR:
MARKET
TBD MORVEN PARK DRIVE
CANTERING HILLS


Job Number: CHCO-0006S-00	Drawing Date: 06/22/21	Coord Name: M. PINGEL-HYATT	Coord Phone: 859.578.4290
House Name: the Gramercy II + Tribeca II			Contract Drawn By: AKS
Born on Date: 04/21/2020			CDs Drawn By: AKS



Sheet Information

0P.2

Overall Building Plan
Elevation 'A'

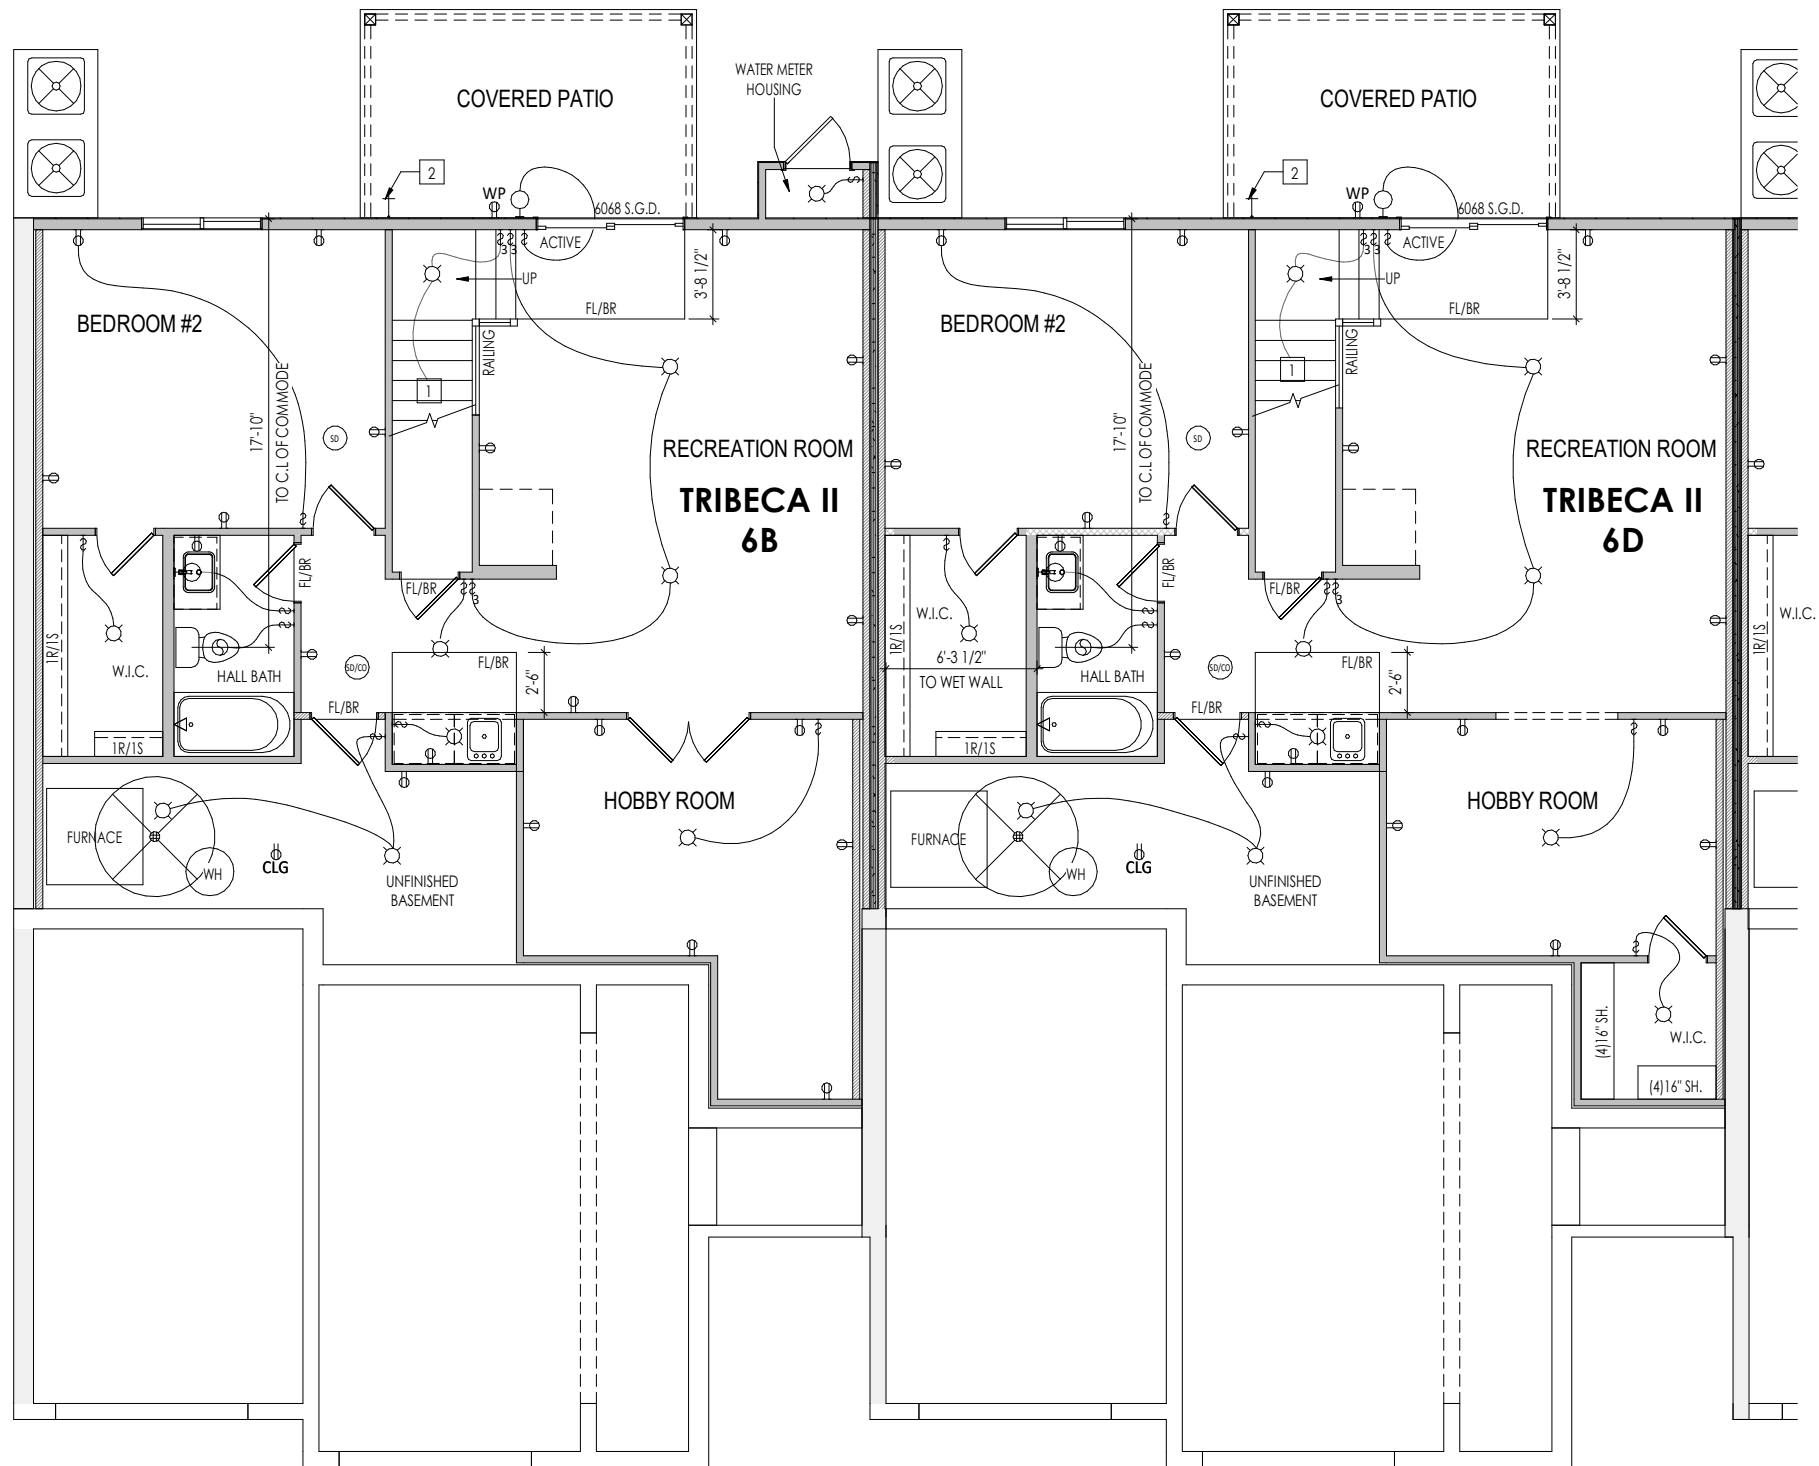

General Notes:

1. REFER TO SHEET ON.1 FOR GENERAL NOTES.

Key Notes:

- 1
- TO LIGHT / SWITCH ABOVE

2

3

4

5

6

7

8

9

10

MECHANICAL LEGEND

- ◀PHONE JACK
⊖WALL OUTLET
⊖WEATHERPROOF GFCI OUTLET
⊖220 VOLT OUTLET
⊖GFCI OUTLET
⊖FLOOR OUTLET
⊖CABLE TELEVISION JACK
⊖SINGLE POLE SWITCH
⊖3-WAY SWITCH
⊖4-WAY SWITCH
⊖BLOCK, MOUNT, & SWITCH FOR FUTURE FAN/LIGHT COMBINATION (CENTER, UNLESS OTHERWISE NOTED)
- ⊖CLG. MOUNTED LIGHT FIXT.
⊖SURFACE MOUNT DISC LIGHT OR RECESSED CEILING LIGHT, PER SPECS.
⊖WALL MOUNTED LIGHT FIXT.
⊖DOUBLE SPOTLIGHT FIXT.
⊖DIRECTIONAL CAN LIGHT
⊖PIN LIGHT
⊖WALL SCONCE @ 5'-6" A.F.F.
⊖FLUORESCENT LIGHT
⊖UNDER CABINET LIGHTING
- ⊖STAIR LIGHT
⊖HOSE BIB
⊖SHOWER HEAD
⊖GAS GAS HOOK UP
⊖FLOOR DRAIN
⊖SMOKE DETECTOR
⊖CO DETECTOR
⊖SMOKE DETECTOR/CO DETECTOR COMBINATION
⊖EXHAUST FAN AND LIGHT COMBINATION
⊖CLG. MTD. EXHAUST FAN

RESIDENCE FOR:
MARKET
TBD MORVEN PARK DRIVE
CANTERING HILLS


Job Number: CHCO-0006S-00	Drawing Date: 06/22/21	Coord Name: M. PINGEL-HYATT	Coord Phone: 859.578.4290
House Name: the Gramercy II + Tribeca II			Contract Drawn By: AKS
			Series: LIFESTYLE
Born on Date: 04/21/2020			CDs Drawn By: AKS



Copyright © 2020. (2020) The Drees Company. All Rights Reserved.
211 Grandview Drive, Fort Mitchell, KY 41017
Phone: [859] 578-4200

Sheet Information

1.03
Lower Level Mechanical Plan
Elevation 'A'

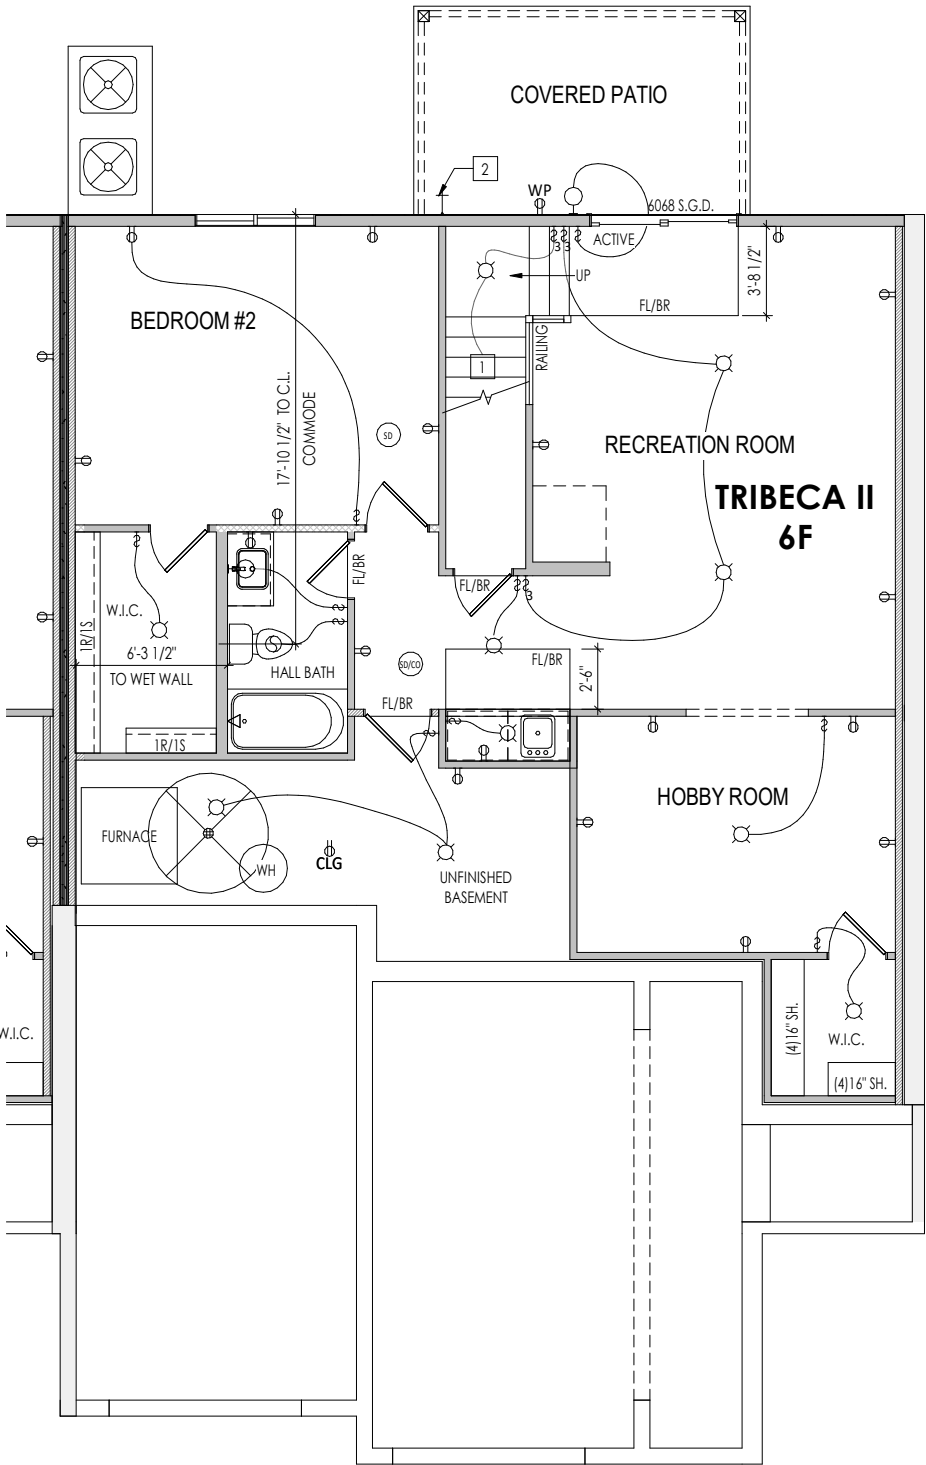

General Notes:

1. REFER TO SHEET ON.1 FOR GENERAL NOTES.

Key Notes:

1

TO LIGHT / SWITCH ABOVE

2

HOSE BIBB - RUN SUPPLY LINE OVERHEAD

3

OUTLET IN JOIST SPACE

4

--

5

--

6

--

7

--

8

--

9

--

10

--

MECHANICAL LEGEND

PHONE JACK

WALL OUTLET

WEATHERPROOF GFCI OUTLET

220 VOLT OUTLET

GFCI OUTLET

FLOOR OUTLET

CABLE TELEVISION JACK

SINGLE POLE SWITCH

3-WAY SWITCH

4-WAY SWITCH

BLOCK, MOUNT, & SWITCH FOR FUTURE FAN/LIGHT COMBINATION (CENTER, UNLESS OTHERWISE NOTED)

CLG. MOUNTED LIGHT FIXT.

SURFACE MOUNT DISC LIGHT OR RECESSED CEILING LIGHT, PER SPECS.

WALL MOUNTED LIGHT FIXT.

DOUBLE SPOTLIGHT FIXT.

DIRECTIONAL CAN LIGHT

PIN LIGHT

WALL SCONCE @ 5'-6" A.F.F.

FLUORESCENT LIGHT

UNDER CABINET LIGHTING

STAIR LIGHT

HOSE BIB

SHOWER HEAD

GAS GAS HOOK UP

FLOOR DRAIN

SMOKE DETECTOR

CO DETECTOR

SMOKE DETECTOR/CO DETECTOR COMBINATION

EXHAUST FAN AND LIGHT COMBINATION

CLG. MTD. EXHAUST FAN

RESIDENCE FOR:

MARKET

TBD MORVEN PARK DRIVE

CANTERING HILLS

Job Number:

CHCO-0006S-00

Drawing Date:

06/22/21

Coord Name:

M. PINGEL-HYATT

Coord Phone:

859.578.4290

House Name:

the Gramercy II + Tribeca II

Drawing Scale:

1/8" = 1'0"

Contract Drawn By:

AKS

Series:

LIFESTYLE

Plan No.:

Born on Date:

04/21/2020

CDs Drawn By:

AKS

Drees

HOMES

SM


Copyright © 2020. (2020) The Drees Company. All Rights Reserved.
211 Grandview Drive, Fort Mitchell, KY 41017
Phone: [859] 578-4200

Sheet Information

1.03.1

Lower Level Mechanical Plan

Elevation 'A'

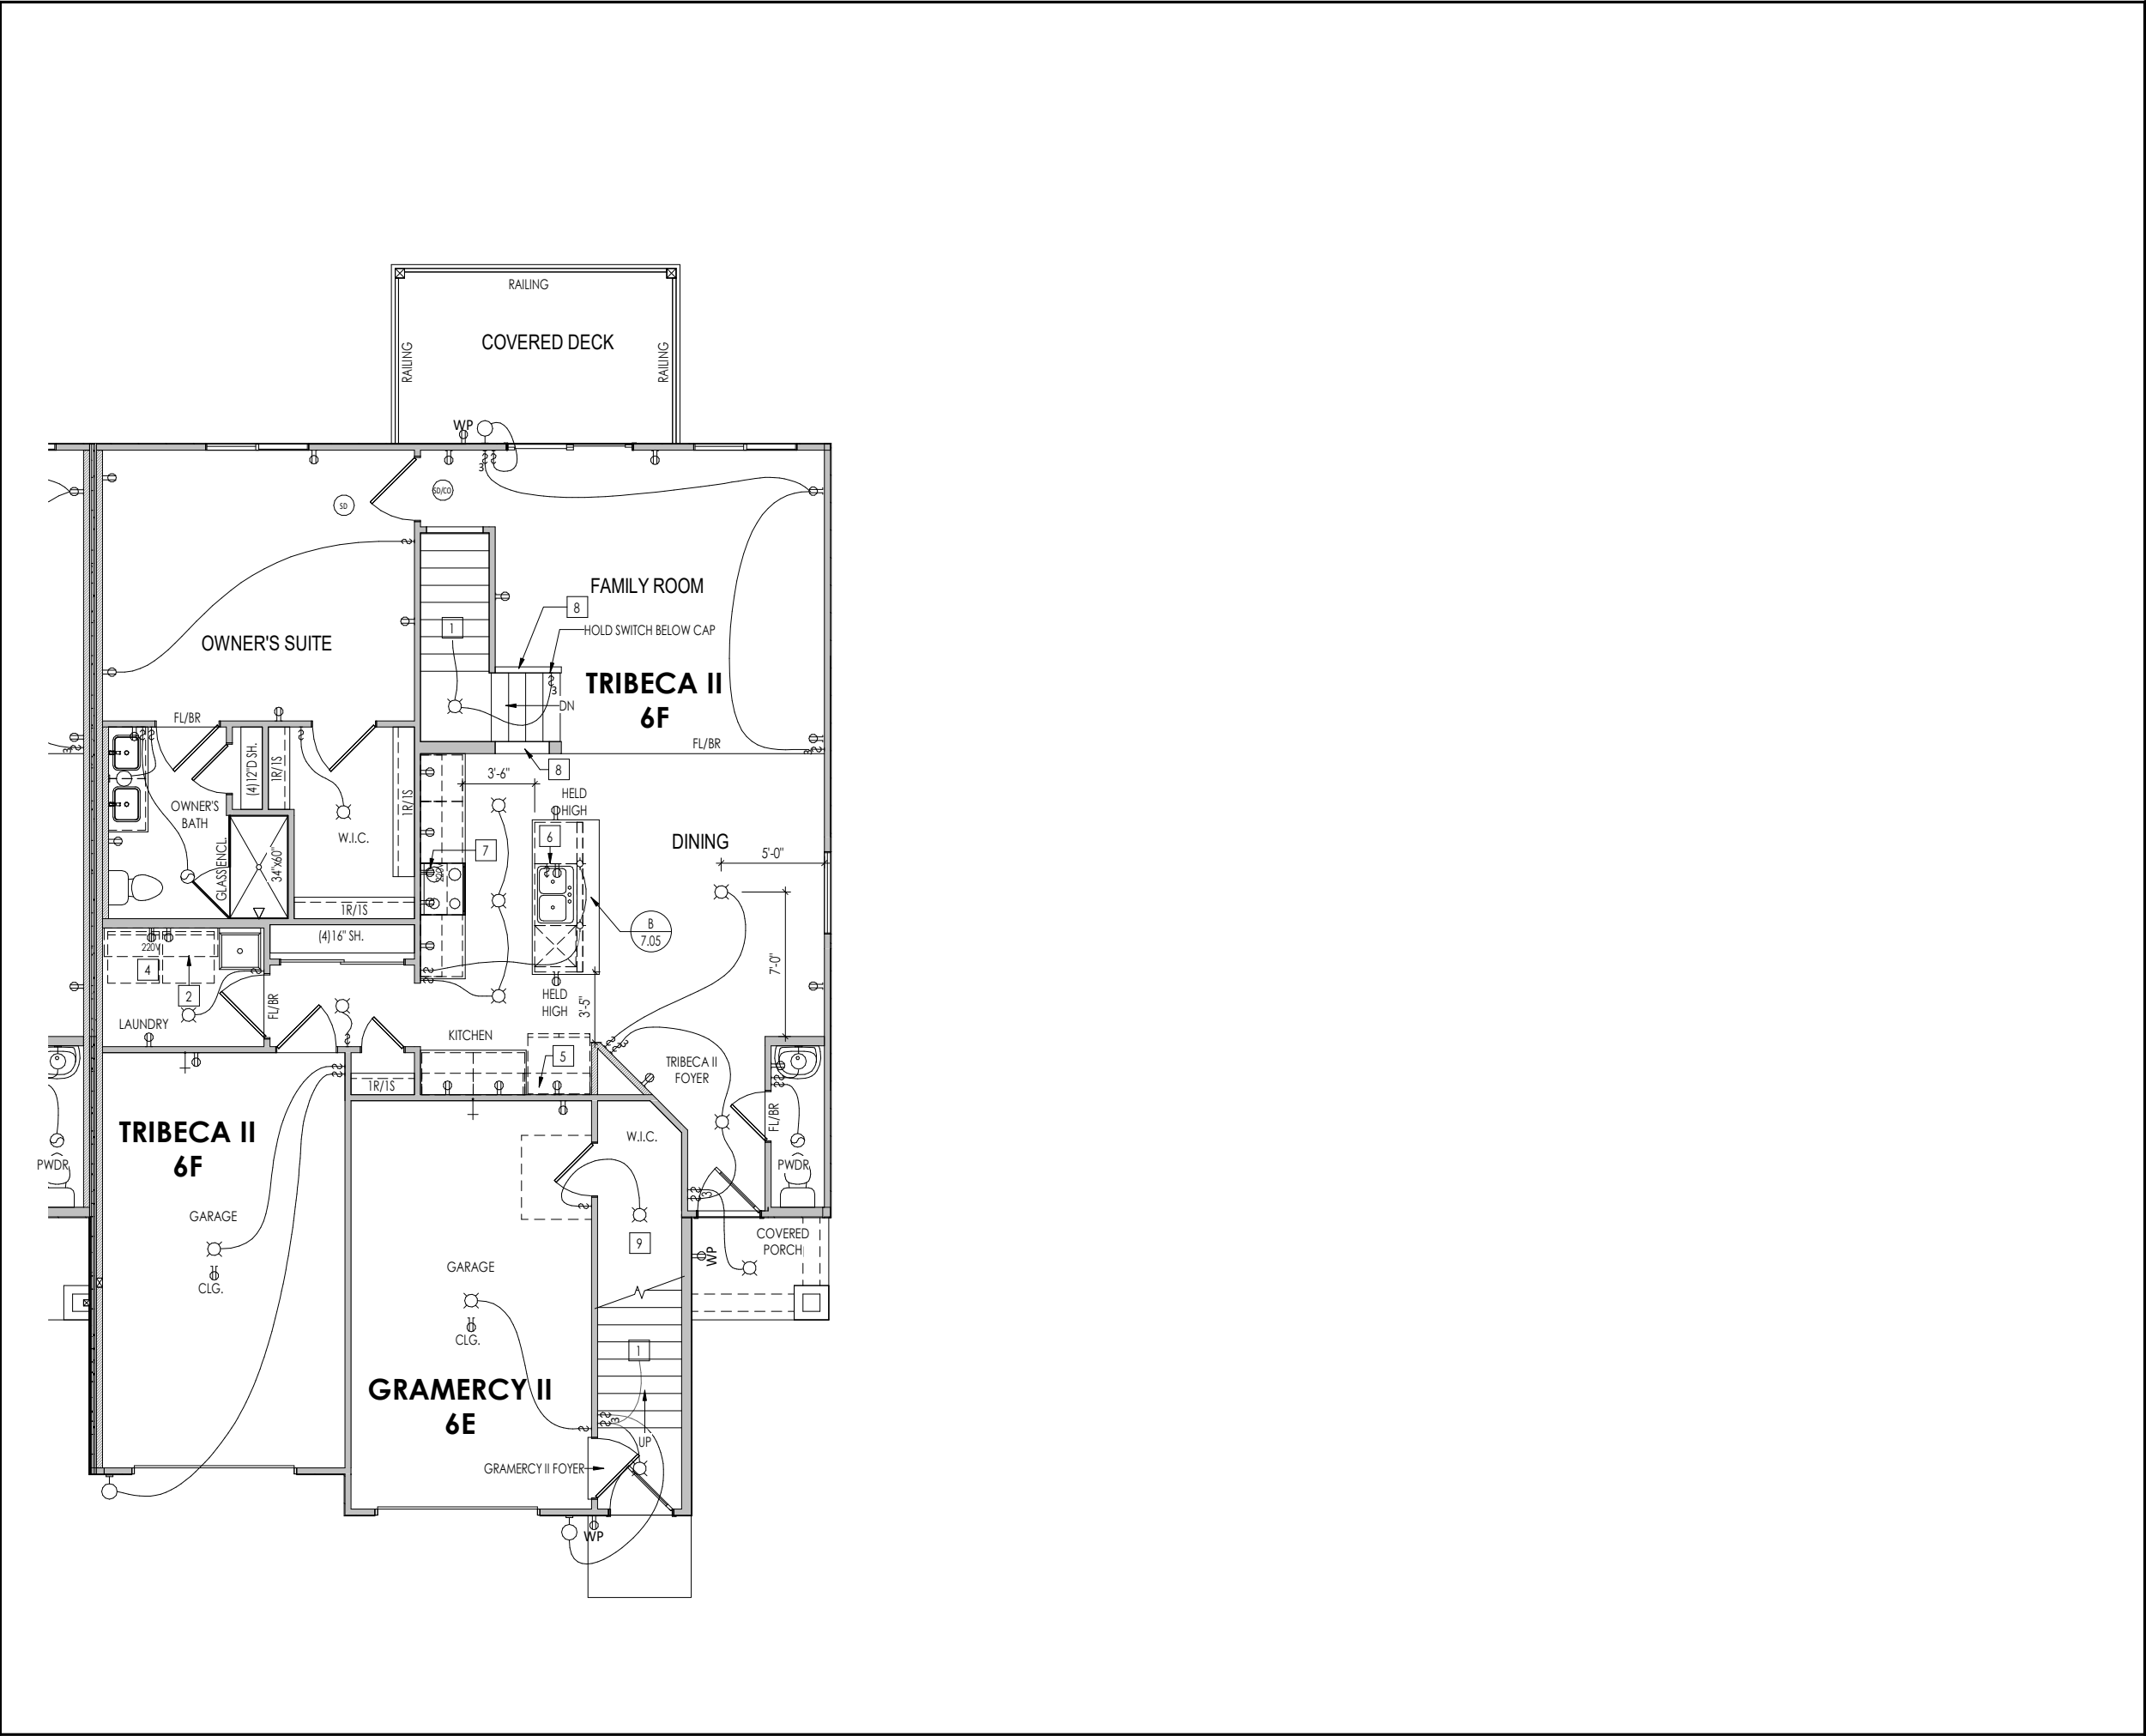

General Notes:

1. REFER TO SHEET ON.1 FOR GENERAL NOTES.

Key Notes:

1

TO SWITCH / LIGHT ABOVE / BELOW

2

16" DEEP SHELF @ 5'-7" A.F.F.

3

OUTLET FOR RANGE HOOD/MICROWAVE HELD HIGH

4

WASHER TO LEFT OF DRYER

5

ALLOW 3'-3" FOR FINISHED CABINET SPACE

6

OUTLET FOR DISHWASHER + SWITCH FOR DISPOSAL LOCATED IN SINK CABINET

7

OUTLET FOR RANGE HOOD/MICROWAVE HELD HIGH

8

WOOD CAP @ HALF WALL

9

DRYWALL CLOSET UNDER STAIRS

10

--

MECHANICAL LEGEND

◀

PHONE JACK

⊖

WALL OUTLET

⊖

WEATHERPROOF
GFCI OUTLET

⊖

220 VOLT OUTLET

⊖

GFCI OUTLET

⊖

FLOOR OUTLET

⊖

CABLE TELEVISION JACK

↔

SINGLE POLE SWITCH

↔

3-WAY SWITCH

↔

4-WAY SWITCH

⊖

CLG. MOUNTED LIGHT FIXT.

○

SURFACE MOUNT DISC LIGHT
OR RECESSED CEILING LIGHT,
PER SPECS.

○

WALL MOUNTED LIGHT FIXT.

⊖

DOUBLE SPOTLIGHT FIXT.

⊖

DIRECTIONAL CAN LIGHT

⊖

PIN LIGHT

⊖

WALL SCONCE @ 5'-6" A.F.F.

⊖

FLUORESCENT LIGHT

⊖

UNDER CABINET LIGHTING

⊖

BLOCK, MOUNT, & SWITCH FOR FUTURE FAN/LIGHT
COMBINATION (CENTER, UNLESS OTHERWISE NOTED)

⬤

STAIR LIGHT

+

HOSE BIB

⚡

SHOWER HEAD

⚡

GAS HOOK UP

⊖

FLOOR DRAIN

⊖

SMOKE DETECTOR

⊖

CO DETECTOR

⊖

SMOKE DETECTOR/
CO DETECTOR
COMBINATION

⊖

EXHAUST FAN AND
LIGHT COMBINATION

⊖

CLG. MTD. EXHAUST FAN

RESIDENCE FOR:

MARKET

TBD MORVEN PARK DRIVE

CANTERING HILLS

Job Number:

CHCO-0006S-00

Drawing Date:

06/22/21

Coord Name:

M. PINGEL-HYATT

Coord Phone:

859.578.4290

House Name:

the Gramercy II + Tribeca II

Drawing Scale:

1/8" = 1'0"

Contract Drawn By:

AKS

Series:

LIFESTYLE

Plan No.:

Born on Date:

04/21/2020

CDs Drawn By:

AKS

Drees

HOMES

SM

Copyright © 2020, (2020) The Drees Company. All Rights Reserved.

211 Grandview Drive, Fort Mitchell, KY 41017


Phone: [859] 578-4200

Sheet Information

4.01.1

First Floor Mechanical Plan

Elevation 'A'

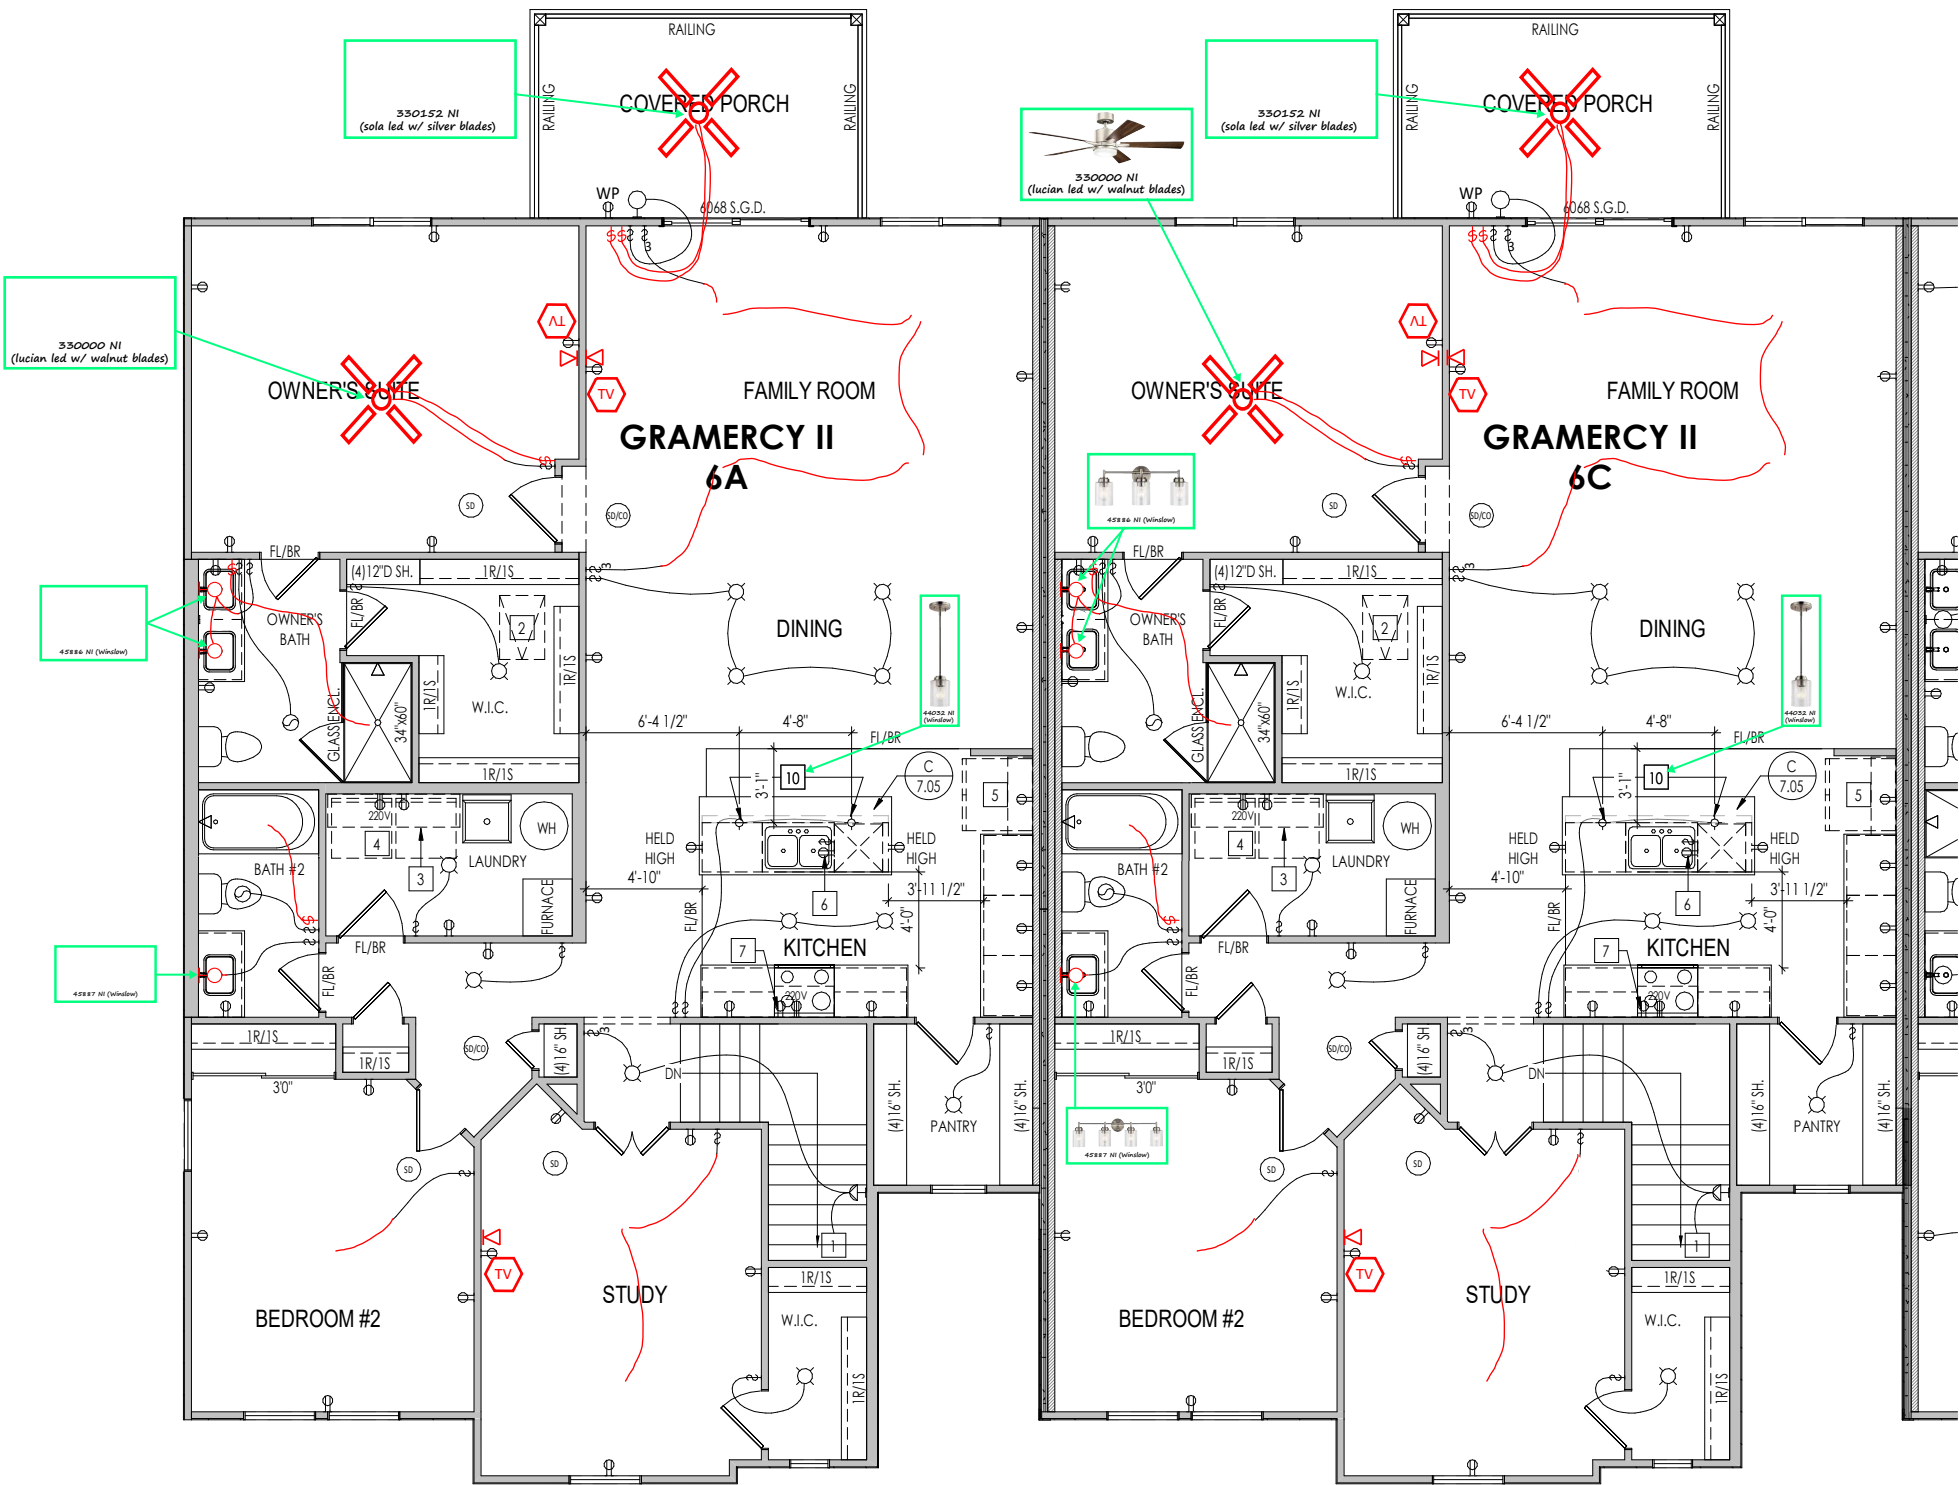

General Notes:

1. REFER TO SHEET ON.1 FOR GENERAL NOTES.

Key Notes:


- 1 TO LIGHT / SWITCH BELOW
- 2 22-1/2"x32" ATTIC ACCESS
- 3 1" SHELF @ 57" A.F.F.
- 4 WASHER TO LEFT OF DRYER
- 5 ALLOW 3'-3" FOR FINISHED CABINET SPACE
- 6 OUTLET FOR DISHWASHER + SWITCH FOR DISPOSAL LOCATED IN SINK CABINET
- 7 OUTLET FOR RANGE HOOD/MICROWAVE HELD HIGH
- 8
- 9
- 10 (2) pendants

MECHANICAL LEGEND

PHONE JACK	CLG. MOUNTED LIGHT FIXT.	STAIR LIGHT
WALL OUTLET	SURFACE MOUNT DISC LIGHT OR RECESSED CEILING LIGHT, PER SPECS.	HOSE BIB
WEATHERPROOF GFCI OUTLET	WALL MOUNTED LIGHT FIXT.	SHOWER HEAD
220 VOLT OUTLET	DOUBLE SPOTLIGHT FIXT.	GAS HOOK UP
GFCI OUTLET	DIRECTIONAL CAN LIGHT	FLOOR DRAIN
FLOOR OUTLET	PIN LIGHT	SMOKE DETECTOR
CABLE TELEVISION JACK	WALL SCONCE @ 5'-6" A.F.F.	CO DETECTOR
SINGLE POLE SWITCH	FLUORESCENT LIGHT	SMOKE DETECTOR/CO DETECTOR COMBINATION
3-WAY SWITCH	UNDER CABINET LIGHTING	EXHAUST FAN AND LIGHT COMBINATION
4-WAY SWITCH		CLG. MTD. EXHAUST FAN
BLOCK, MOUNT, & SWITCH FOR FUTURE FAN/LIGHT COMBINATION (CENTER, UNLESS OTHERWISE NOTED)		

RESIDENCE FOR:
MARKET
TBD MORVEN PARK DRIVE
CANTERING HILLS

Job Number: CHCO-0006S-00	Drawing Date: 06/22/21	Coord Name: M. PINGEL-HYATT	Coord Phone: 859.578.4290
House Name: the Gramercy II + Tribeca II			Contract Drawn By: AKS
Born on Date: 04/21/2020			Series: LIFESTYLE
CDs Drawn By: AKS			Plan No.:

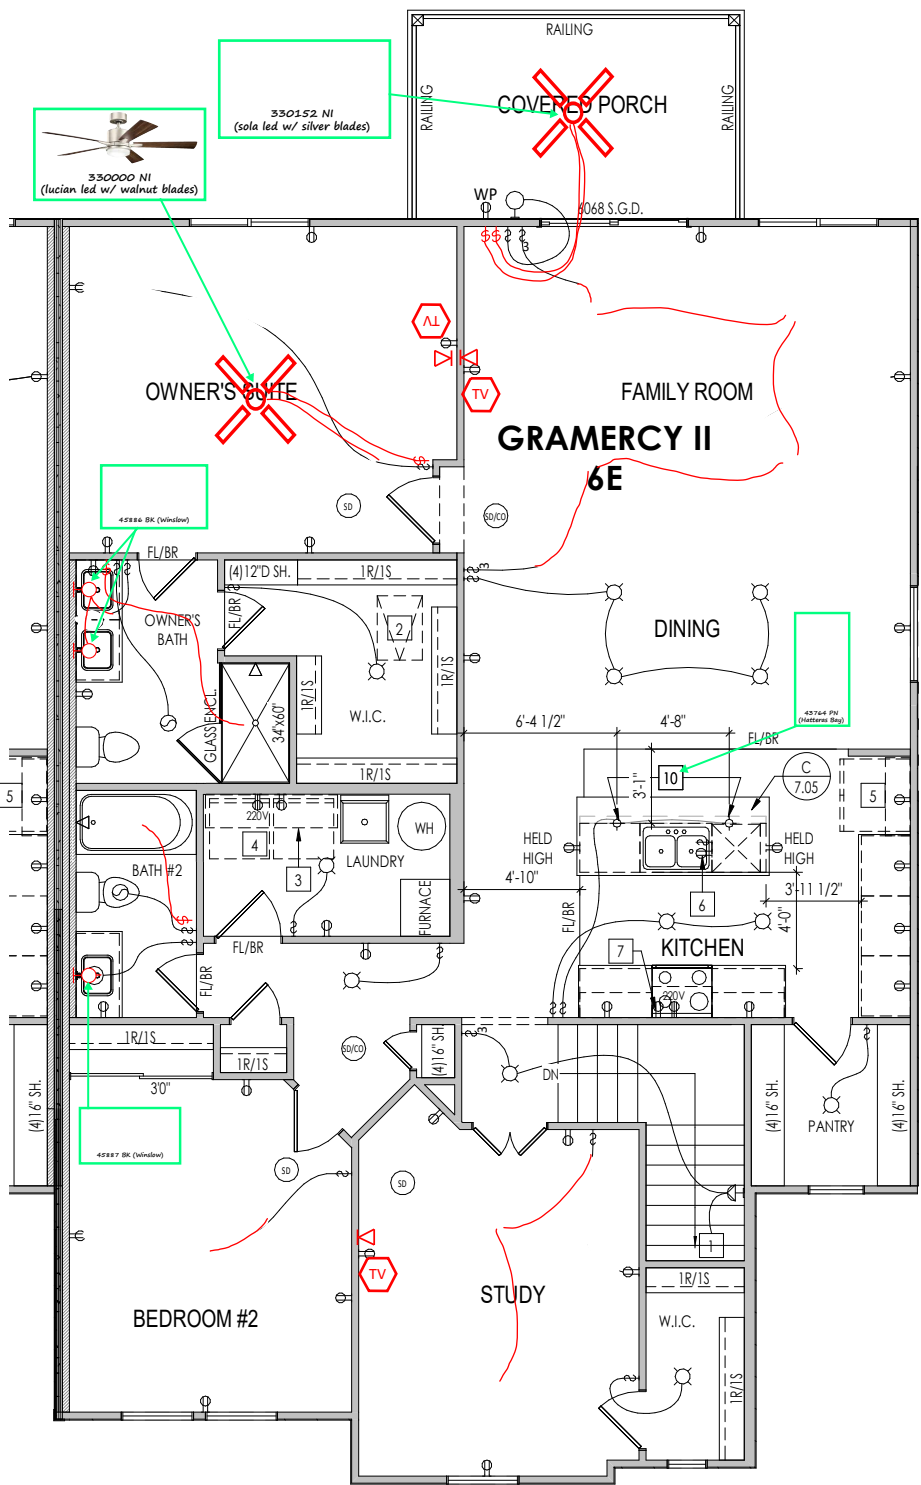

General Notes:

1. REFER TO SHEET ON.1 FOR GENERAL NOTES.

Key Notes:

- 1 TO LIGHT / SWITCH BELOW
- 2 22-1/2"x32" ATTIC ACCESS
- 3 16" SHELF @ 57" A.F.F.
- 4 WASHER TO LEFT OF DRYER
- 5 ALLOW 3'-3" FOR FINISHED CABINET SPACE
- 6 OUTLET FOR DISHWASHER + SWITCH FOR DISPOSAL LOCATED IN SINK CABINET
- 7 OUTLET FOR RANGE HOOD/MICROWAVE HELD HIGH
- 8
- 9
- 10

MECHANICAL LEGEND

- | | | |
|--|--|--|
| ◀ PHONE JACK | ○ CLG. MOUNTED LIGHT FIXT. | ■ STAIR LIGHT |
| ⊖ WALL OUTLET | ○ SURFACE MOUNT DISC LIGHT OR RECESSED CEILING LIGHT, PER SPECS. | + HOSE BIB |
| ⊖ WEATHERPROOF GFCI OUTLET | ○ WALL MOUNTED LIGHT FIXT. | △ SHOWER HEAD |
| ⊖ 220 VOLT OUTLET | ⊖ DOUBLE SPOTLIGHT FIXT. | ⊖ GAS GAS HOOK UP |
| ⊖ GFCI OUTLET | ⊖ DIRECTIONAL CAN LIGHT | ⊖ FLOOR DRAIN |
| ⊖ FLOOR OUTLET | ⊖ PIN LIGHT | ⊖ SMOKE DETECTOR |
| ⊖ CABLE TELEVISION JACK | ⊖ WALL SCONCE @ 5'-6" A.F.F. | ⊖ CO DETECTOR |
| ⊖ SINGLE POLE SWITCH | ⊖ FLUORESCENT LIGHT | ⊖ SMOKE DETECTOR/CO DETECTOR COMBINATION |
| ⊖ 3-WAY SWITCH | ⊖ UNDER CABINET LIGHTING | ⊖ EXHAUST FAN AND LIGHT COMBINATION |
| ⊖ 4-WAY SWITCH | | ⊖ CLG. MTD. EXHAUST FAN |
| ⊖ BLOCK, MOUNT, & SWITCH FOR FUTURE FAN/LIGHT COMBINATION (CENTER, UNLESS OTHERWISE NOTED) | | |

RESIDENCE FOR:
MARKET
TBD MORVEN PARK DRIVE
CANTERING HILLS

Job Number: CHCO-0006S-00	Drawing Date: 06/22/21	Coord Name: M. PINGEL-HYATT	Coord Phone: 859.578.4290
House Name: the Gramercy II + Tribeca II			Contract Drawn By: AKS
			Series: LIFESTYLE
Born on Date: 04/21/2020			CDs Drawn By: AKS



Sheet Information
4.02.1
Second Floor Mechanical Plan
Elevation 'A'

TYPICAL TRIM:

6" FASCIA
(ALL SIDES)


8" FRIEZE
(FRONT ONLY, UNLESS OTHERWISE NOTED)

General Notes:

1. REFER TO SHEET 0N.1 FOR GENERAL NOTES.
2. ROOFING MATERIAL PER SELECTIONS.
3. CONTACT M&K ENGINEERING FOR HEADER SIZE/BRICK SUPPORT IF GRADE DROPS AND THE AMOUNT OF BRICK OVER GARAGE DOOR SHOWN ON CURRENT ELEVATION IS NO LONGER ACCURATE

Key Notes:

- 1 -
- 2 -
- 3 -
- 4 -

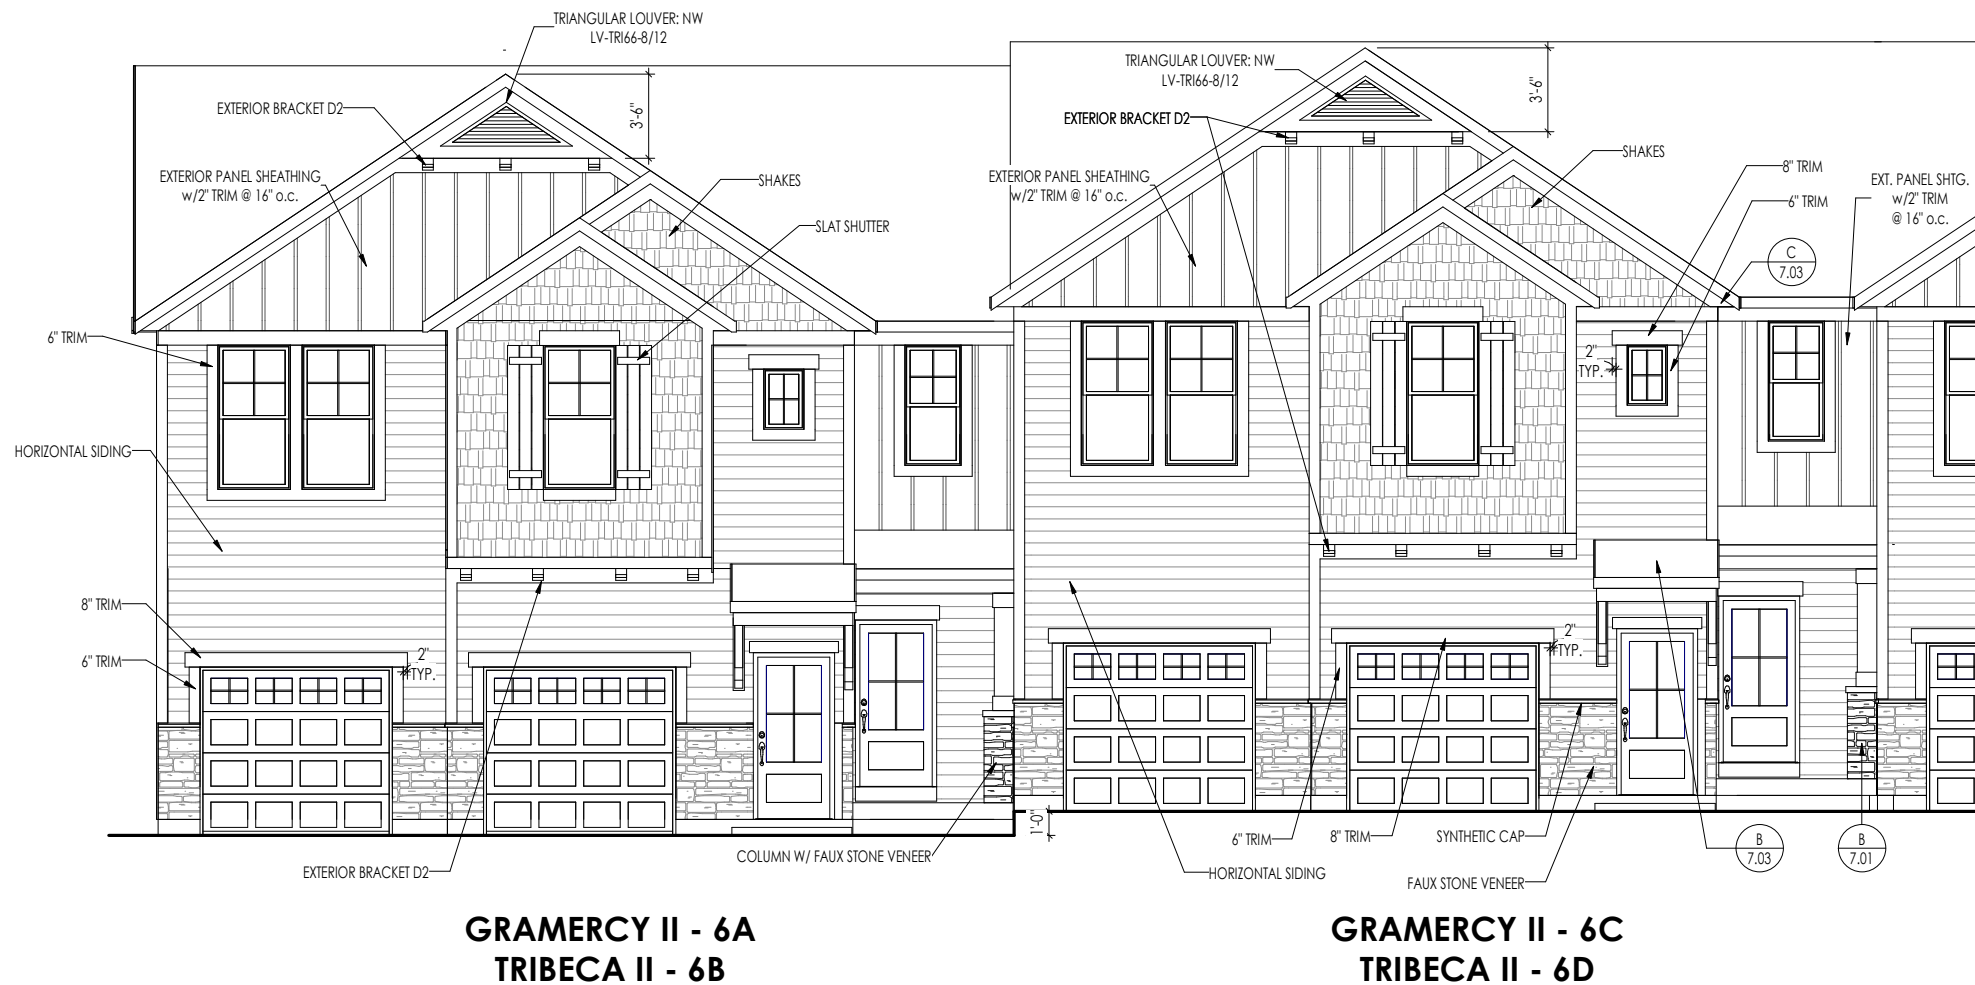


RESIDENCE FOR:
MARKET
TBD MORVEN PARK DRIVE
CANTERING HILLS

Job Number: CHCO-0006S-00	Drawing Date: 06/22/21	Coord Name: M. PINGEL-HYATT	Coord Phone: 859.578.4290
House Name: the Gramercy II + Tribeca II			Contract Drawn By: AKS
Born on Date: 04/21/2020			Series: LIFESTYLE
CDs Drawn By: AKS			Plan No.:

Copyright © 2020. (2020) The Drees Company. All Rights Reserved.
211 Grandview Drive, Fort Mitchell, KY 41017
Phone: [859] 578-4200

Sheet Information

6.01
Front Elevation
Elevation 'A'

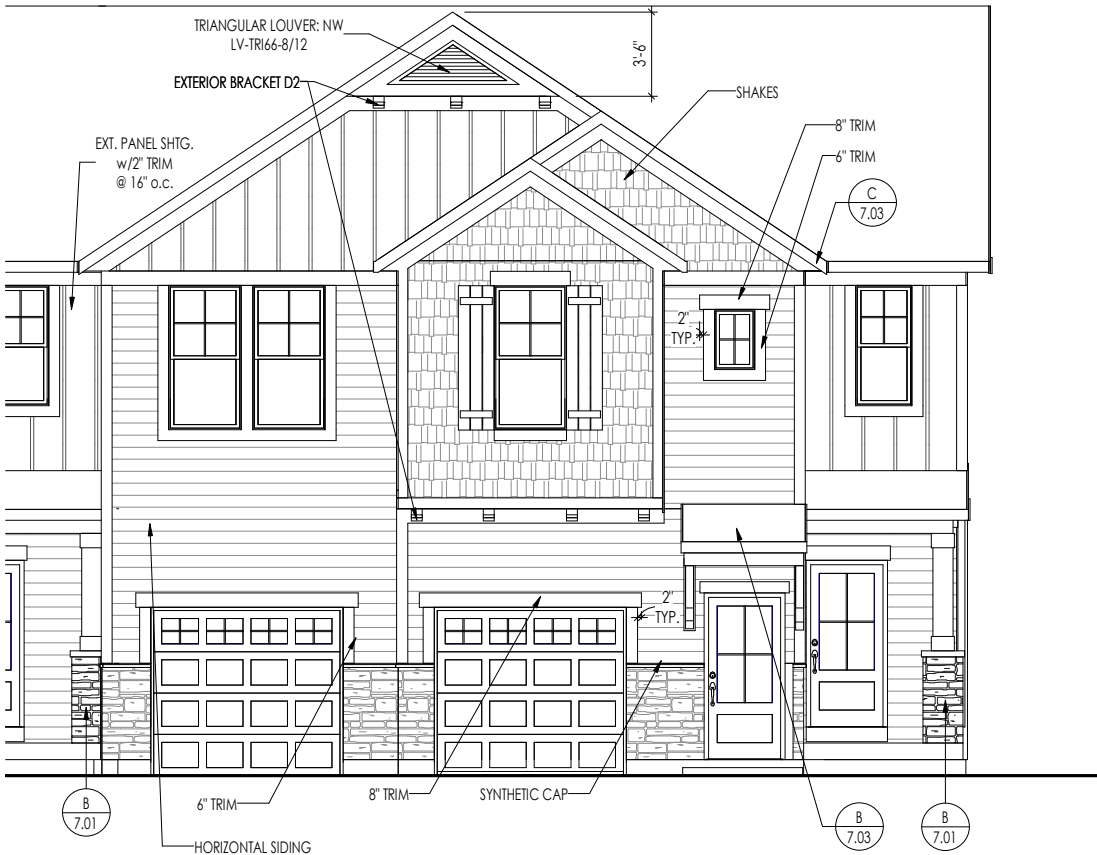

GRAMERCY II - 6E
TRIBECA II - 6F

TYPICAL TRIM:
6" FASCIA (ALL SIDES)
8" FRIEZE (FRONT ONLY, UNLESS OTHERWISE NOTED)

General Notes:	
1. REFER TO SHEET 0N.1 FOR GENERAL NOTES. 2. ROOFING MATERIAL PER SELECTIONS. 3. CONTACT M&K ENGINEERING FOR HEADER SIZE/BRICK SUPPORT IF GRADE DROPS AND THE AMOUNT OF BRICK OVER GARAGE DOOR SHOWN ON CURRENT ELEVATION IS NO LONGER ACCURATE	
Key Notes:	
1	--
2	--
3	--
4	--

RESIDENCE FOR: MARKET TBD MORVEN PARK DRIVE CANTERING HILLS			
Job Number: CHCO-0006S-00	Drawing Date: 06/22/21	Coord Name: M. PINGEL-HYATT	Coord Phone: 859.578.4290
House Name:			Contract Drawn By: AKS
the Gramercy II + Tribeca II			Series: LIFESTYLE
			Plan No.:
Born on Date: 04/21/2020	CDs Drawn By: AKS		
 Copyright © 2020. (2020) The Drees Company. All Rights Reserved. 211 Grandview Drive, Fort Mitchell, KY 41017 Phone: [859] 578-4200		Sheet Information	6.01.1 Front Elevation Elevation 'A'