

General Notes:

- REFER TO SHEET ON.1 FOR GENERAL NOTES.

Key Notes:

401A	TO SWITCH OR LIGHT ABOVE
401C	SEE DETAIL B/7.01 FOR KITCHEN ISLAND COUNTERTOP DIMENSIONS
401D	HOLD OUTLET HIGH ON ISLAND
401E	OUTLET FOR RANGE HOOD HELD HIGH
401F	OUTLET FOR DISHWASHER LOCATED IN SINK CABINET
401G	SWITCH FOR GARBAGE DISPOSAL LOCATED IN SINK CABINET
401H	LOCATE WASHER TO LEFT OF DRYER
401J	16" DEEP x 5'-6" LONG SHELF HELD AT 5'-7" A.F.F.

MECHANICAL LEGEND


◀ PHONE JACK	○ CLG. MOUNTED LIGHT FIXT.	■ STAIR LIGHT
⊖ WALL OUTLET	○ SURFACE MOUNT DISC LIGHT OR RECESSED CEILING LIGHT, PER SPECS.	+ HOSE BIB
⊖ WEATHERPROOF GFCI OUTLET	○ WALL MOUNTED LIGHT FIXT.	△ SHOWER HEAD
⊖ 220 VOLT OUTLET	○ DOUBLE SPOTLIGHT FIXT.	⊖ GAS HOOK UP
⊖ GFCI OUTLET	○ DIRECTIONAL CAN LIGHT	⊖ FLOOR DRAIN
⊖ FLOOR OUTLET	○ PIN LIGHT	⊖ SMOKE DETECTOR
⊖ CABLE TELEVISION JACK	⊖ WALL SCONCE @ 5'-6" A.F.F.	⊖ CO DETECTOR
⊖ SINGLE POLE SWITCH	⊖ FLUORESCENT LIGHT	⊖ SMOKE DETECTOR/CO DETECTOR COMBINATION
⊖ 3-WAY SWITCH	⊖ UNDER CABINET LIGHTING	⊖ EXHAUST FAN AND LIGHT COMBINATION
⊖ 4-WAY SWITCH		⊖ CLG. MTD. EXHAUST FAN
⊖ BLOCK, MOUNT, & SWITCH FOR FUTURE FAN/LIGHT COMBINATION (CENTER, UNLESS OTHERWISE NOTED)		

Space for Architect Seal

**RESIDENCE FOR:
MODEL
3108 BOB LANE
MERRITT VILLAGE**

Job Number: MTV-0009-B	Drawing Date: 10/01/2021	Coord Name: LISA C.	Coord Phone: 8595784322
House Name:		Drawing Scale: 1/8" = 1'0"	Contract Drawn By: WAB
the TRUETT			Series: 300
			Plan No.: 2842
Born on Date: 09/30/2021	CDs Drawn By: WAB		

<p>Drees CUSTOM HOMESSM</p> <p><small>Copyright © 2021 (2021) The Drees Company. All Rights Reserved. 6225 State Highway 161, Suite 400, Irving, TX 75038 Phone: (972) 953-4500</small></p>	Sheet Information	4.01
	<p>First Floor Mechanical Plan Elevation "B"</p>	

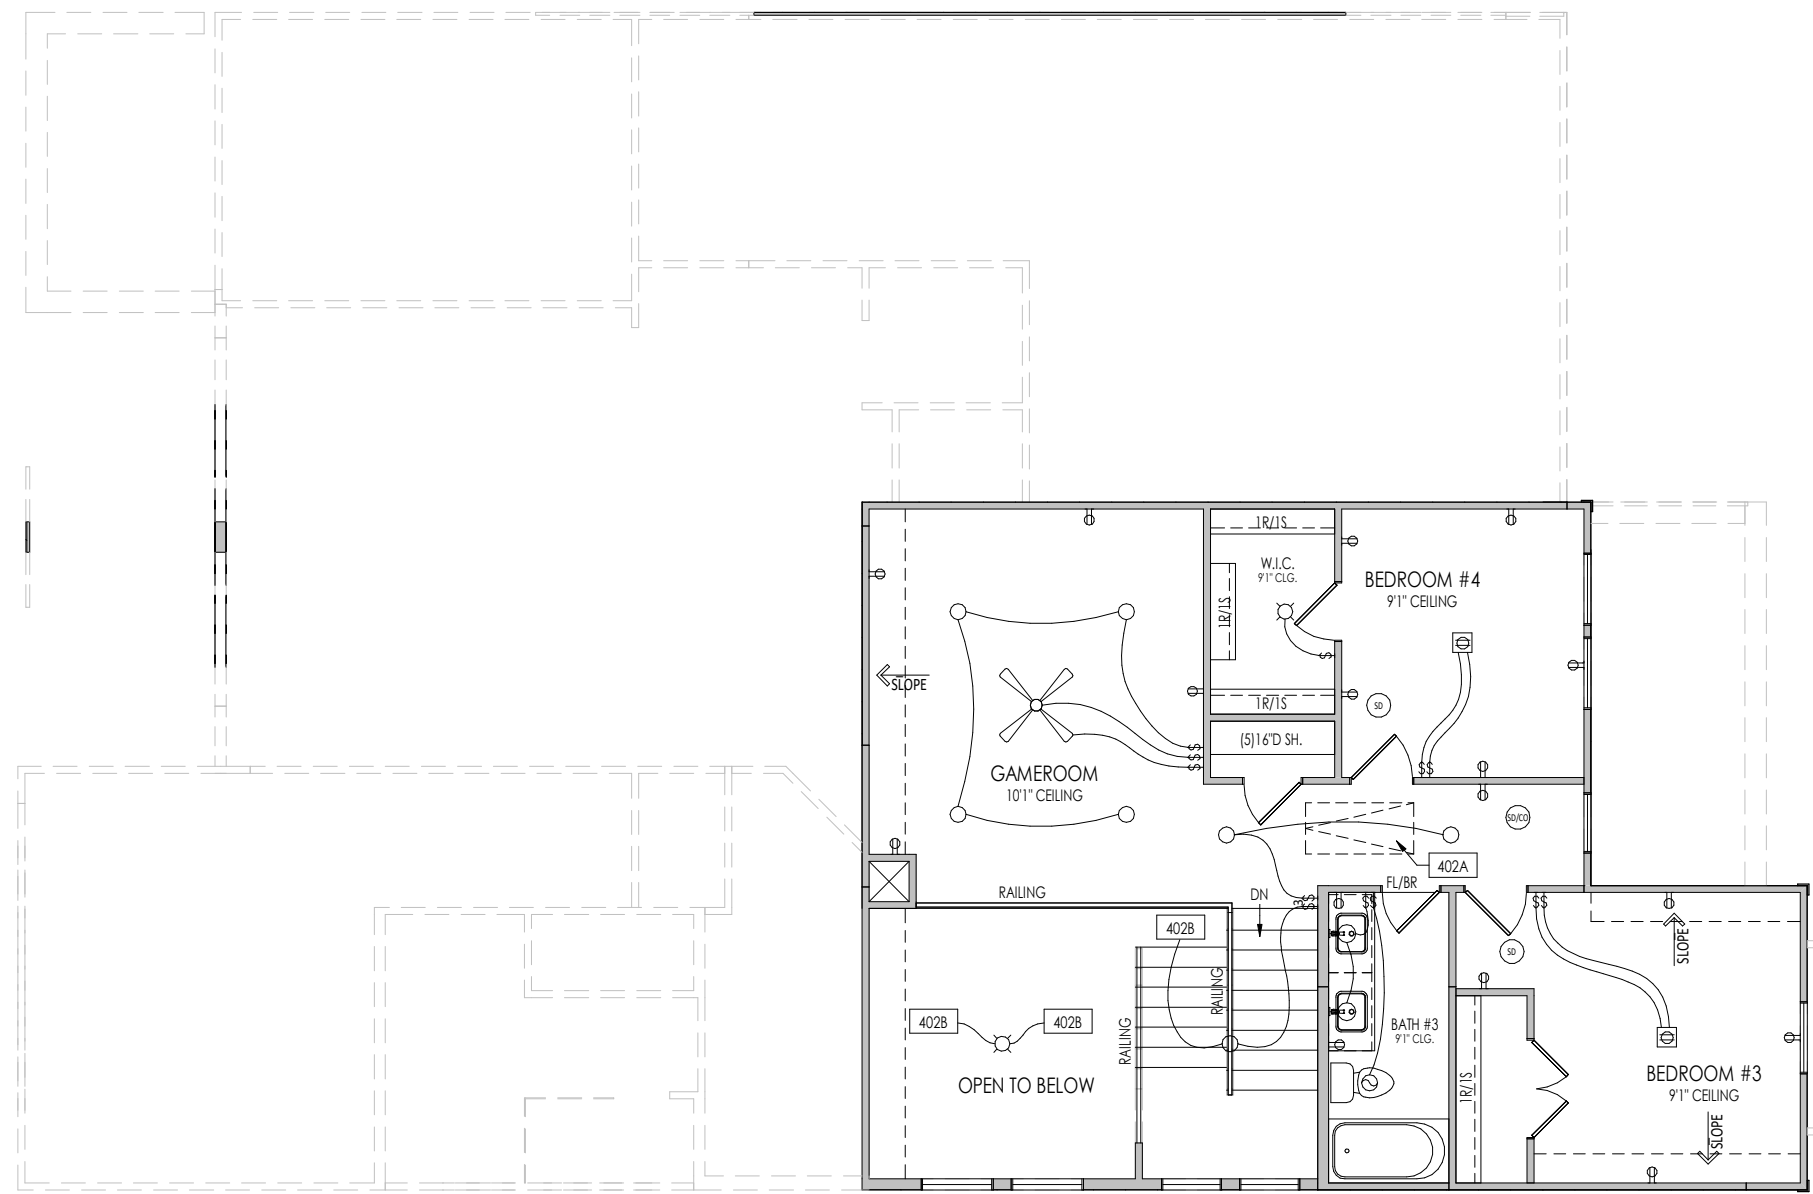

General Notes:

1. REFER TO SHEET ON.1 FOR GENERAL NOTES.

Key Notes:

402A 25-1/2"x54" PULL DOWN ATTIC ACCESS STAIRS W/ LIGHT AND OUTLET
 402B TO SWITCH OR LIGHT BELOW

MECHANICAL LEGEND

- | | | |
|----------------------------|--|--|
| ◀ PHONE JACK | ○ CLG. MOUNTED LIGHT FIXT. | ■ STAIR LIGHT |
| ⊖ WALL OUTLET | ○ SURFACE MOUNT DISC LIGHT OR RECESSED CEILING LIGHT, PER SPECS. | + HOSE BIB |
| ⊖ WEATHERPROOF GFCI OUTLET | ○ WALL MOUNTED LIGHT FIXT. | △ SHOWER HEAD |
| ⊖ 220 VOLT OUTLET | ⊖ DOUBLE SPOTLIGHT FIXT. | ⊖ GAS GAS HOOK UP |
| ⊖ GFCI OUTLET | ⊖ DIRECTIONAL CAN LIGHT | ⊖ FLOOR DRAIN |
| ⊖ FLOOR OUTLET | ⊖ PIN LIGHT | ⊖ SMOKE DETECTOR |
| ⊖ CABLE TELEVISION JACK | ⊖ WALL SCONCE @ 5'-6" A.F.F. | ⊖ CO DETECTOR |
| ↔ SINGLE POLE SWITCH | ⊖ FLUORESCENT LIGHT | ⊖ SMOKE DETECTOR/CO DETECTOR COMBINATION |
| ↔ 3-WAY SWITCH | ⊖ UNDER CABINET LIGHTING | ⊖ EXHAUST FAN AND LIGHT COMBINATION |
| ↔ 4-WAY SWITCH | ⊖ BLOCK, MOUNT, & SWITCH FOR FUTURE FAN/LIGHT COMBINATION (CENTER, UNLESS OTHERWISE NOTED) | ⊖ CLG. MTD. EXHAUST FAN |

Space for Architect Seal

RESIDENCE FOR:
MODEL
 3108 BOB LANE
 MERRITT VILLAGE

Job Number: MTV-0009-B	Drawing Date: 10/01/2021	Coord Name: LISA C.	Coord Phone: 8595784322
House Name: the TRUETT			Contract Drawn By: WAB
Born on Date: 09/30/2021			Series: 300
CDs Drawn By: WAB			Plan No.: 2842

Drees
CUSTOM HOMESSM

Copyright © 2021 (2021) The Drees Company. All Rights Reserved.
6225 State Highway 161, Suite 400, Irving, TX 75038
Phone: (972) 953-4500

4.02

Second Floor Mechanical Plan
Elevation "B"

Sheet Information