
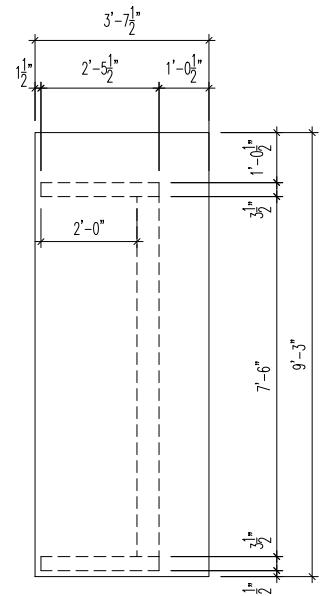


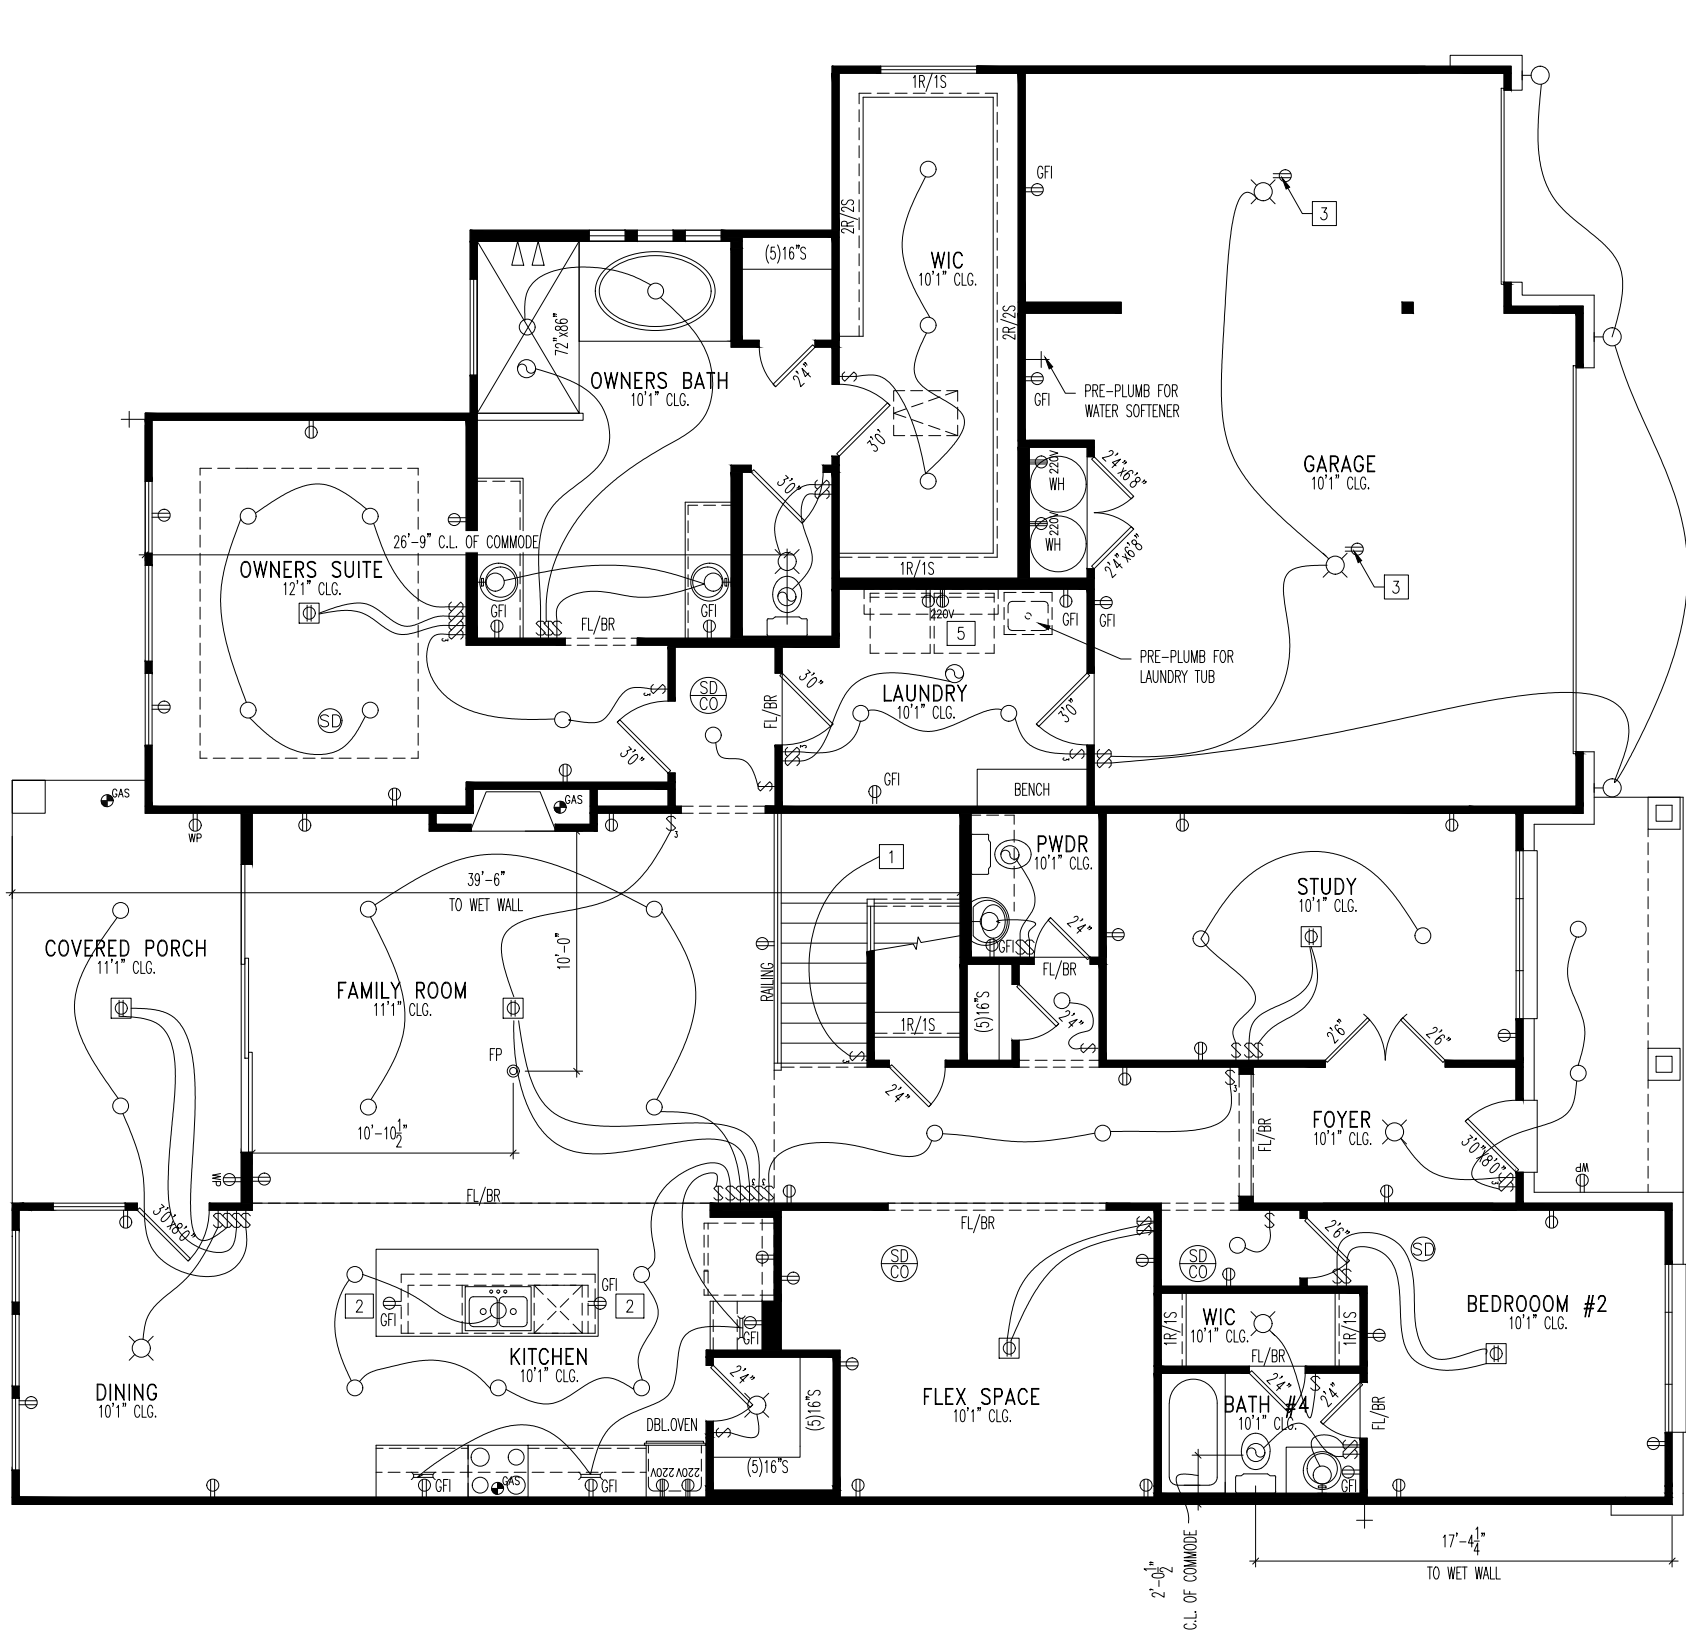

ISLAND DETAIL
SCALE: 1/4" = 1'-0"

General Notes

1. REFER TO SHEET ON.1 FOR GENERAL NOTES.

Key Notes

- 1 TO LIGHT OR SWITCH
- 2 HOLD OUTLET HIGH ON ISLAND
- 3 OUTLET IN CEILING
- 4 OUTLET @ 45° A.F.F.
- 5 WASHER TO THE LEFT OF DRYER
- 6 --
- 7 --
- 8 --
- 9 PULL DOWN STAIRS W/ LIGHT AND OUTLET (25 1/2" x 54")
- 10 --

Mechanical Legend

PHONE JACK	FLUORESCENT LIGHT
HOME OFFICE OUTLET	UNDER CABINET LIGHTING
DATA OUTLET	CLG. MOUNTED LIGHT FIXT.
PROJECTOR ROUGH-IN	WALL MOUNTED LIGHT FIXT.
ENTERTAINMENT CENTER OUTLET	SURFACE MOUNT DISC LIGHT OR RECESSED CEILING LIGHT PER SPECS.
WALL OUTLET	DOUBLE SPOTLIGHT FIXT.
WEATHERPROOF OUTLET	DIRECTIONAL CAN LIGHT
220 OUTLET	PIN LIGHT
GROUND FAULT OUTLET	WALL SCONCE @ 5'-6" A.F.F.
CABLE TELEVISION JACK	STAIR LIGHT
SINGLE POLE SWITCH	CLG. MTD. EXHAUST FAN
3-WAY SWITCH	WALL MTD. EXHAUST FAN
4-WAY SWITCH	SMOKE DETECTOR
BLOCK, MOUNT, & SWITCH FOR FUTURE FAN/LIGHT COMBINATION (CENTER, UNLESS OTHERWISE NOTED)	HOSE BIB
EXHAUST FAN AND LIGHT COMBINATION	SHOWER HEAD
FLOOR DRAIN	GAS HOOK UP
	CO DETECTOR
	SMOKE DETECTOR/CO DETECTOR COMBINATION

House:

DEERFIELD II

Series:
SERIES_NM

Plan No.:
5166

Std. Drawn By: STD_BY

Std. Chk. By: ARC

Std. Date: STD_DATE

Date of Last Rev: REV_DATE

Sheet Description:

FIRST FLOOR MECHANICAL PLAN
ELEVATION "G"

SCALE: 1/8" = 1'-0"

Contract Drawn By:

Phone #:

Coordinator's Name:

Coordinator's Phone #:

SMT-0125-00 Contract.dwg Sep 13, 2021 - 7:39am

GS

-

LISA C

(859) 578-4322

Original Site Specific Dwg. & Effective Change Order Date:

9/10/2021

Subdivision:

THE SUMMIT AT LAKE TRAVIS

Job #:

SMT-0125-00

Customer Name:


MARKET

Job Address:

2517 SUNSET VISTA CIRCLE

Sheet No.

4.01

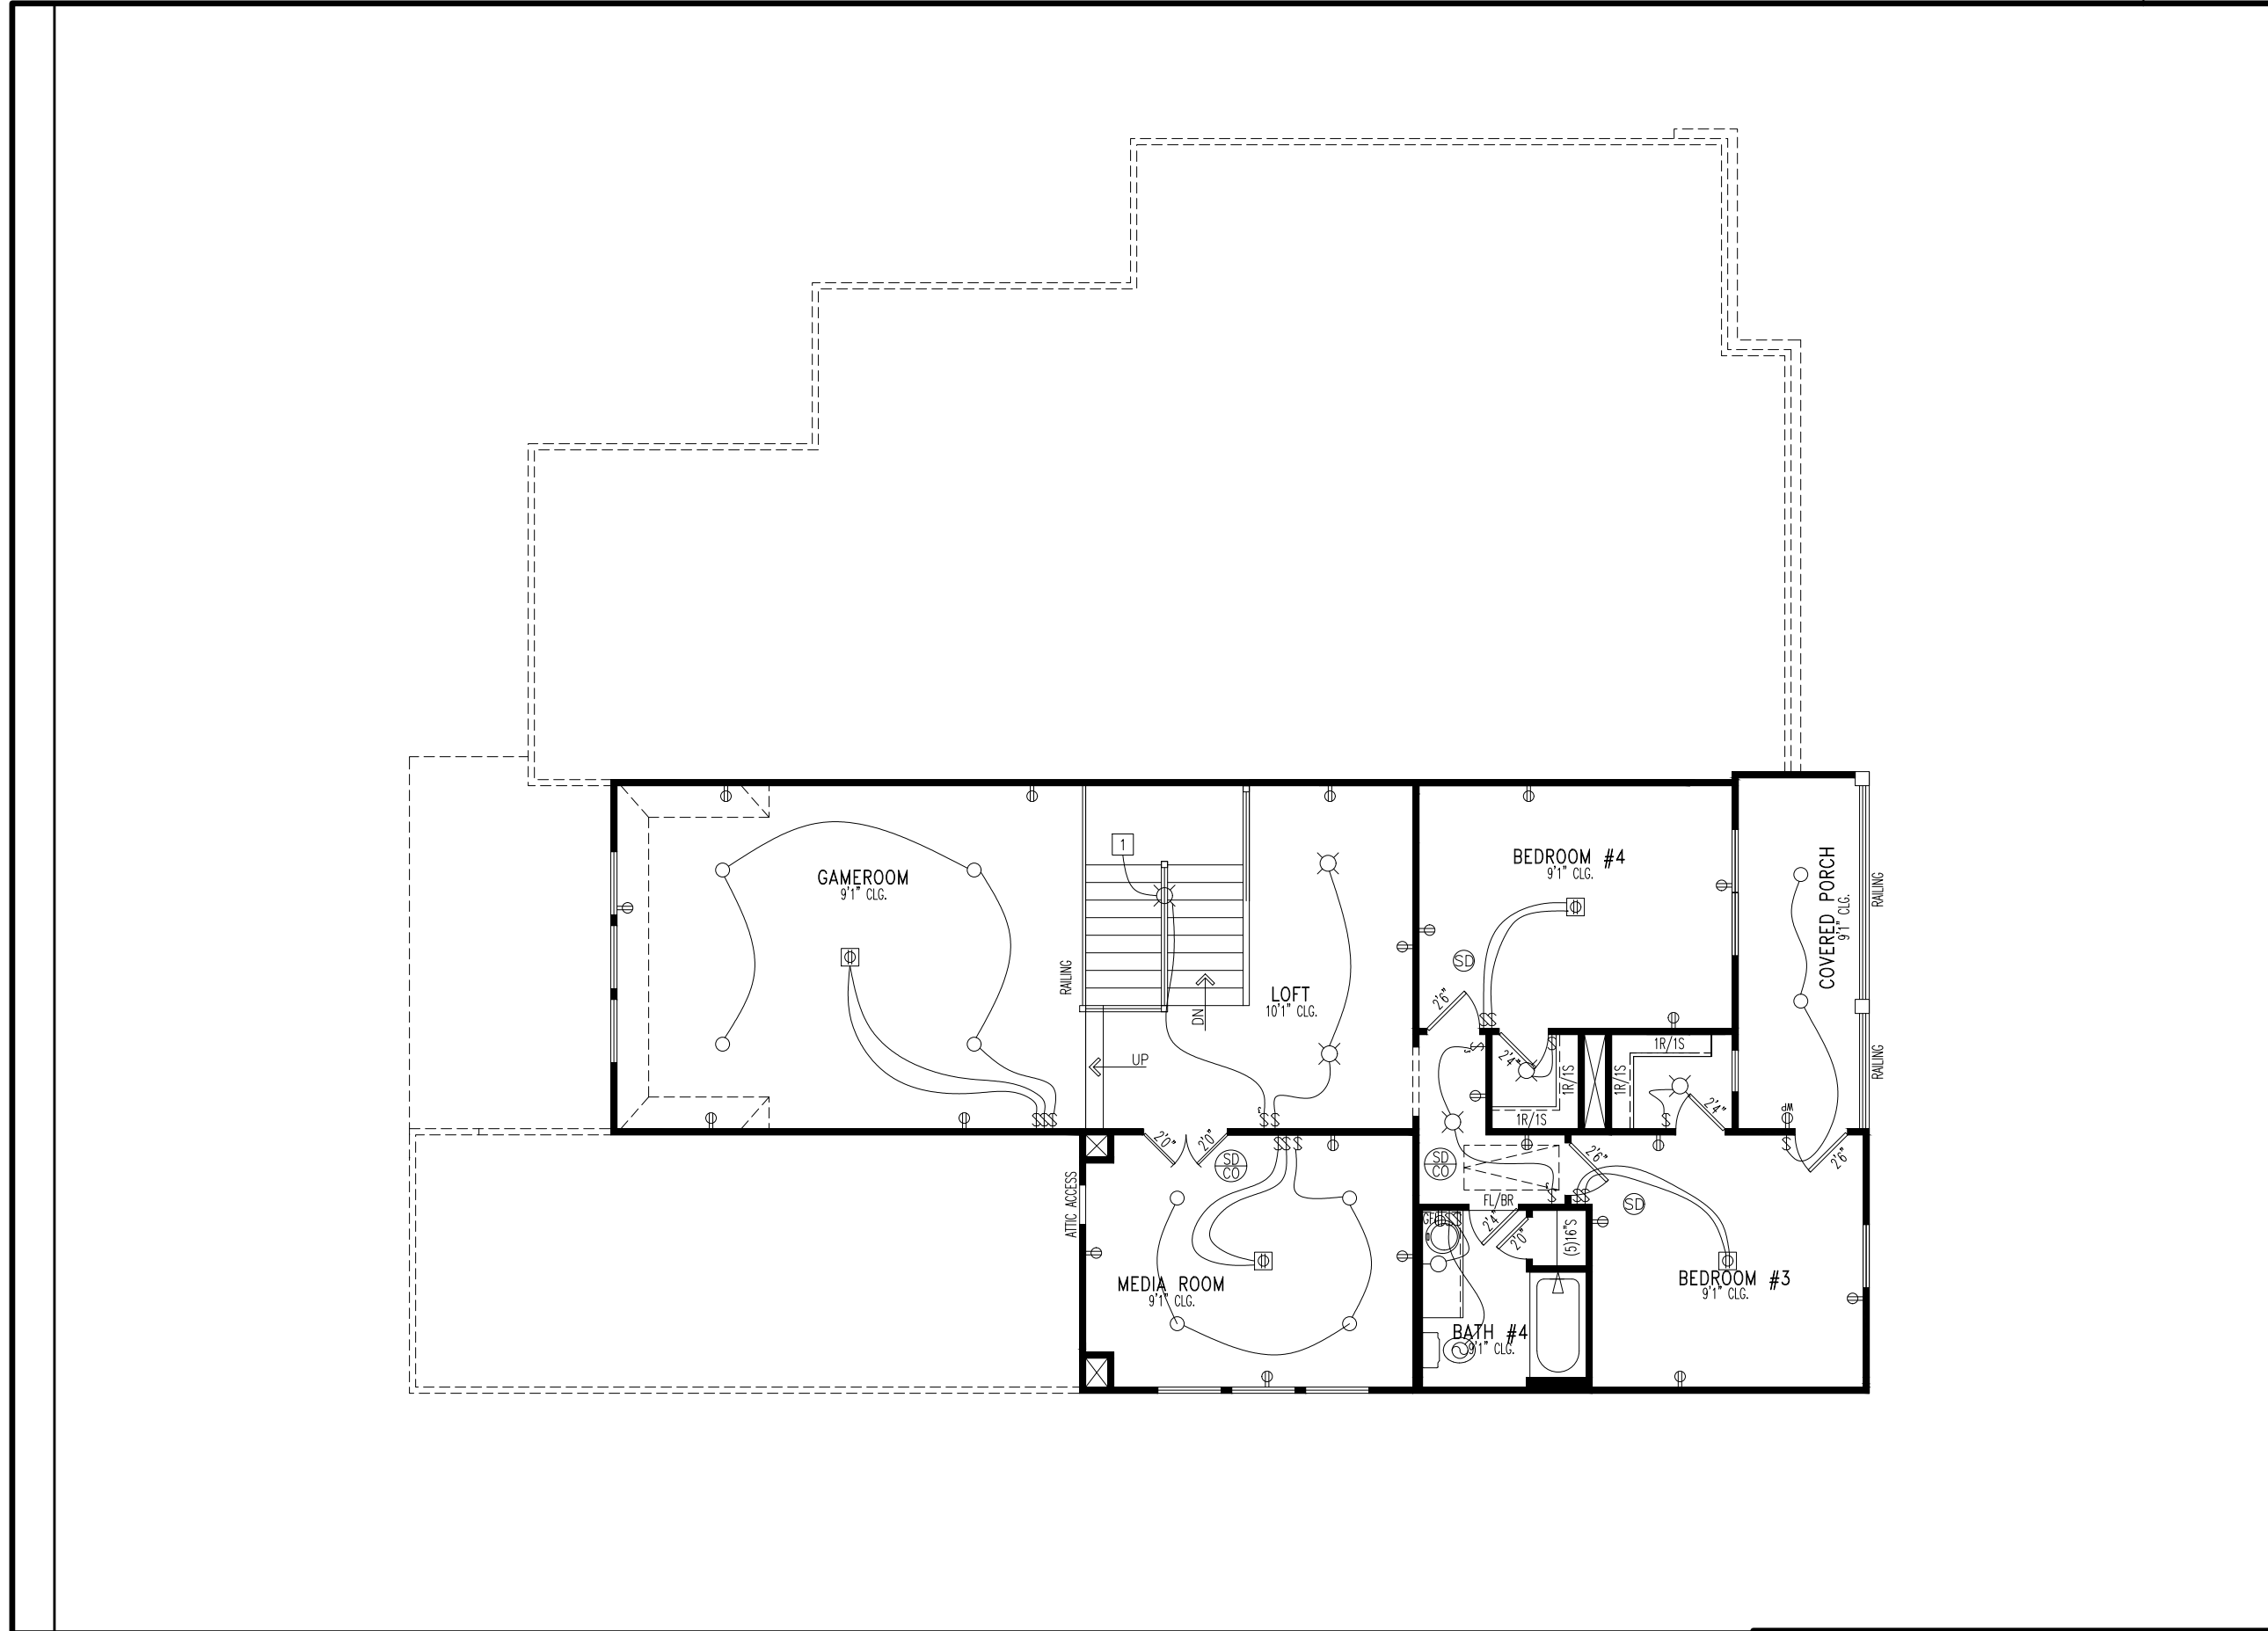

General Notes

1. REFER TO SHEET ON.1 FOR GENERAL NOTES.

Key Notes

- 1 TO LIGHT OR SWITCH
- 2 --
- 3 42" HALF WALL W/ WOOD CAP.
- 4 --
- 5 --
- 6 --
- 7 --
- 8 --
- 9 --
- 10 --

Mechanical Legend

PHONE JACK

HOME OFFICE OUTLET

DATA OUTLET

PROJECTOR ROUGH-IN

ENTERTAINMENT CENTER OUTLET

WALL OUTLET

WEATHERPROOF OUTLET

220 OUTLET

GROUND FAULT OUTLET

FLOOR OUTLET

CABLE TELEVISION JACK

SINGLE POLE SWITCH

3-WAY SWITCH

4-WAY SWITCH

BLOCK, MOUNT, & SWITCH FOR FUTURE FAN/LIGHT COMBINATION (CENTER, UNLESS OTHERWISE NOTED)

EXHAUST FAN AND LIGHT COMBINATION

FLOOR DRAIN

FLUORESCENT LIGHT

UNDER CABINET LIGHTING

CLG. MOUNTED LIGHT FIXT.

WALL MOUNTED LIGHT FIXT.

SURFACE MOUNT DISC LIGHT OR RECESSED CEILING LIGHT PER SPECS.

DOUBLE SPOTLIGHT FIXT.

DIRECTIONAL CAN LIGHT

PIN LIGHT

WALL SCONCE @ 5'-6" A.F.F.

STAIR LIGHT

CLG. MTD. EXHAUST FAN

WALL MTD. EXHAUST FAN

SMOKE DETECTOR

HOSE BIB

SHOWER HEAD

GAS

CO DETECTOR

SMOKE DETECTOR/CO DETECTOR COMBINATION



EXTERIOR MATERIAL:
9% STUCCO
91% STUCCO



NOTE:
6" FASCIA
4" FRIEZE

General Notes

1. REFER TO SHEET ON.1 FOR GENERAL NOTES.
2. ROOFING MATERIAL PER SPECIFICATIONS

Key Notes

- 1 CAST STONE HEADERS ABOVE DOORS AND WINDOWS
- 2
- 3
- 4
- 5
- 6 STUCCO PER SUBDIVISION SPECS
- 7
- 8
- 9
- 10

BRICK and STONE LINTEL SCHEDULE

	SPAN	36" HIGH	48" HIGH	LINTEL SIZE	WINDOW ABOVE
*BRICK	Up to 6'-0"	---	---	L3 1/2 x 3 1/2 x 1/4	---
	Up to 8'-3"	---	---	L5 x 3 1/2 x 5/16	---
	Up to 9'-3"	---	---	L6 x 4 x 3/16	L7 x 4 x 3/8
	Up to 16'-3"	L7 x 4 x 3/8	L8 x 4 x 1/2	L8 x 4 x 1/2	**per Design
*STONE	Up to 6'-0"	---	---	L4 x 3 1/2 x 1/4	---
	Up to 8'-3"	---	---	L5 x 3 1/2 x 5/16	---
	Up to 9'-3"	---	L6 x 4 x 3/8	L7 x 4 x 3/8	**per Design
	Up to 16'-3"	---	L8 x 4 x 1/2	**per Design	**per Design

All Lintels: 4" Minimum bearing required each end
* Brick is based on 40psf and Stone is based on 60psf
** Any lintels not described by the above parameters shall be specifically designed.



DREES CUSTOM HOMES L.P.
11305 FOUR POINTS DRIVE BUILDING 1, SUITE 150 AUSTIN, TX 78726
(512) 241-7100

Copyright © 2018, (2020) The Drees Company. All Rights Reserved. No portion of this material may be reproduced in any form or by any means, including photocopying, without the express written permission of the Drees Company. The Drees Company will vigorously prosecute any unauthorized use of this material.

House:

DEERFIELD II

Series:
SERIES_NM

Plan No.:
5166

Std. Drawn By: STD_BY

Std. Chk. By: ARC

Std. Date: STD_DATE

Date of Last Rev: REV_DATE

Sheet Description:

SCALE: 1/8" = 1'-0"

FRONT & REAR ELEVATIONS
ELEVATION "G"

Contract Drawn By:

GS

Phone #:

-

Coordinator's Name:

LISA C

Coordinator's Phone #:

(859)578-4322

Original Site Specific Dwg. &
Effective Change Order Date:

9/10/2021

Subdivision:

THE SUMMIT AT LAKE TRAVIS

Job #:

SMT-0125-00

Customer Name:

MARKET

Job Address:

2517 SUNSET VISTA CIRCLE

Sheet No.

6.01