


Autodesk Docs | Drees Architecture | TRA-00325-00 | Zuri and Lucia Duplex | 1/1

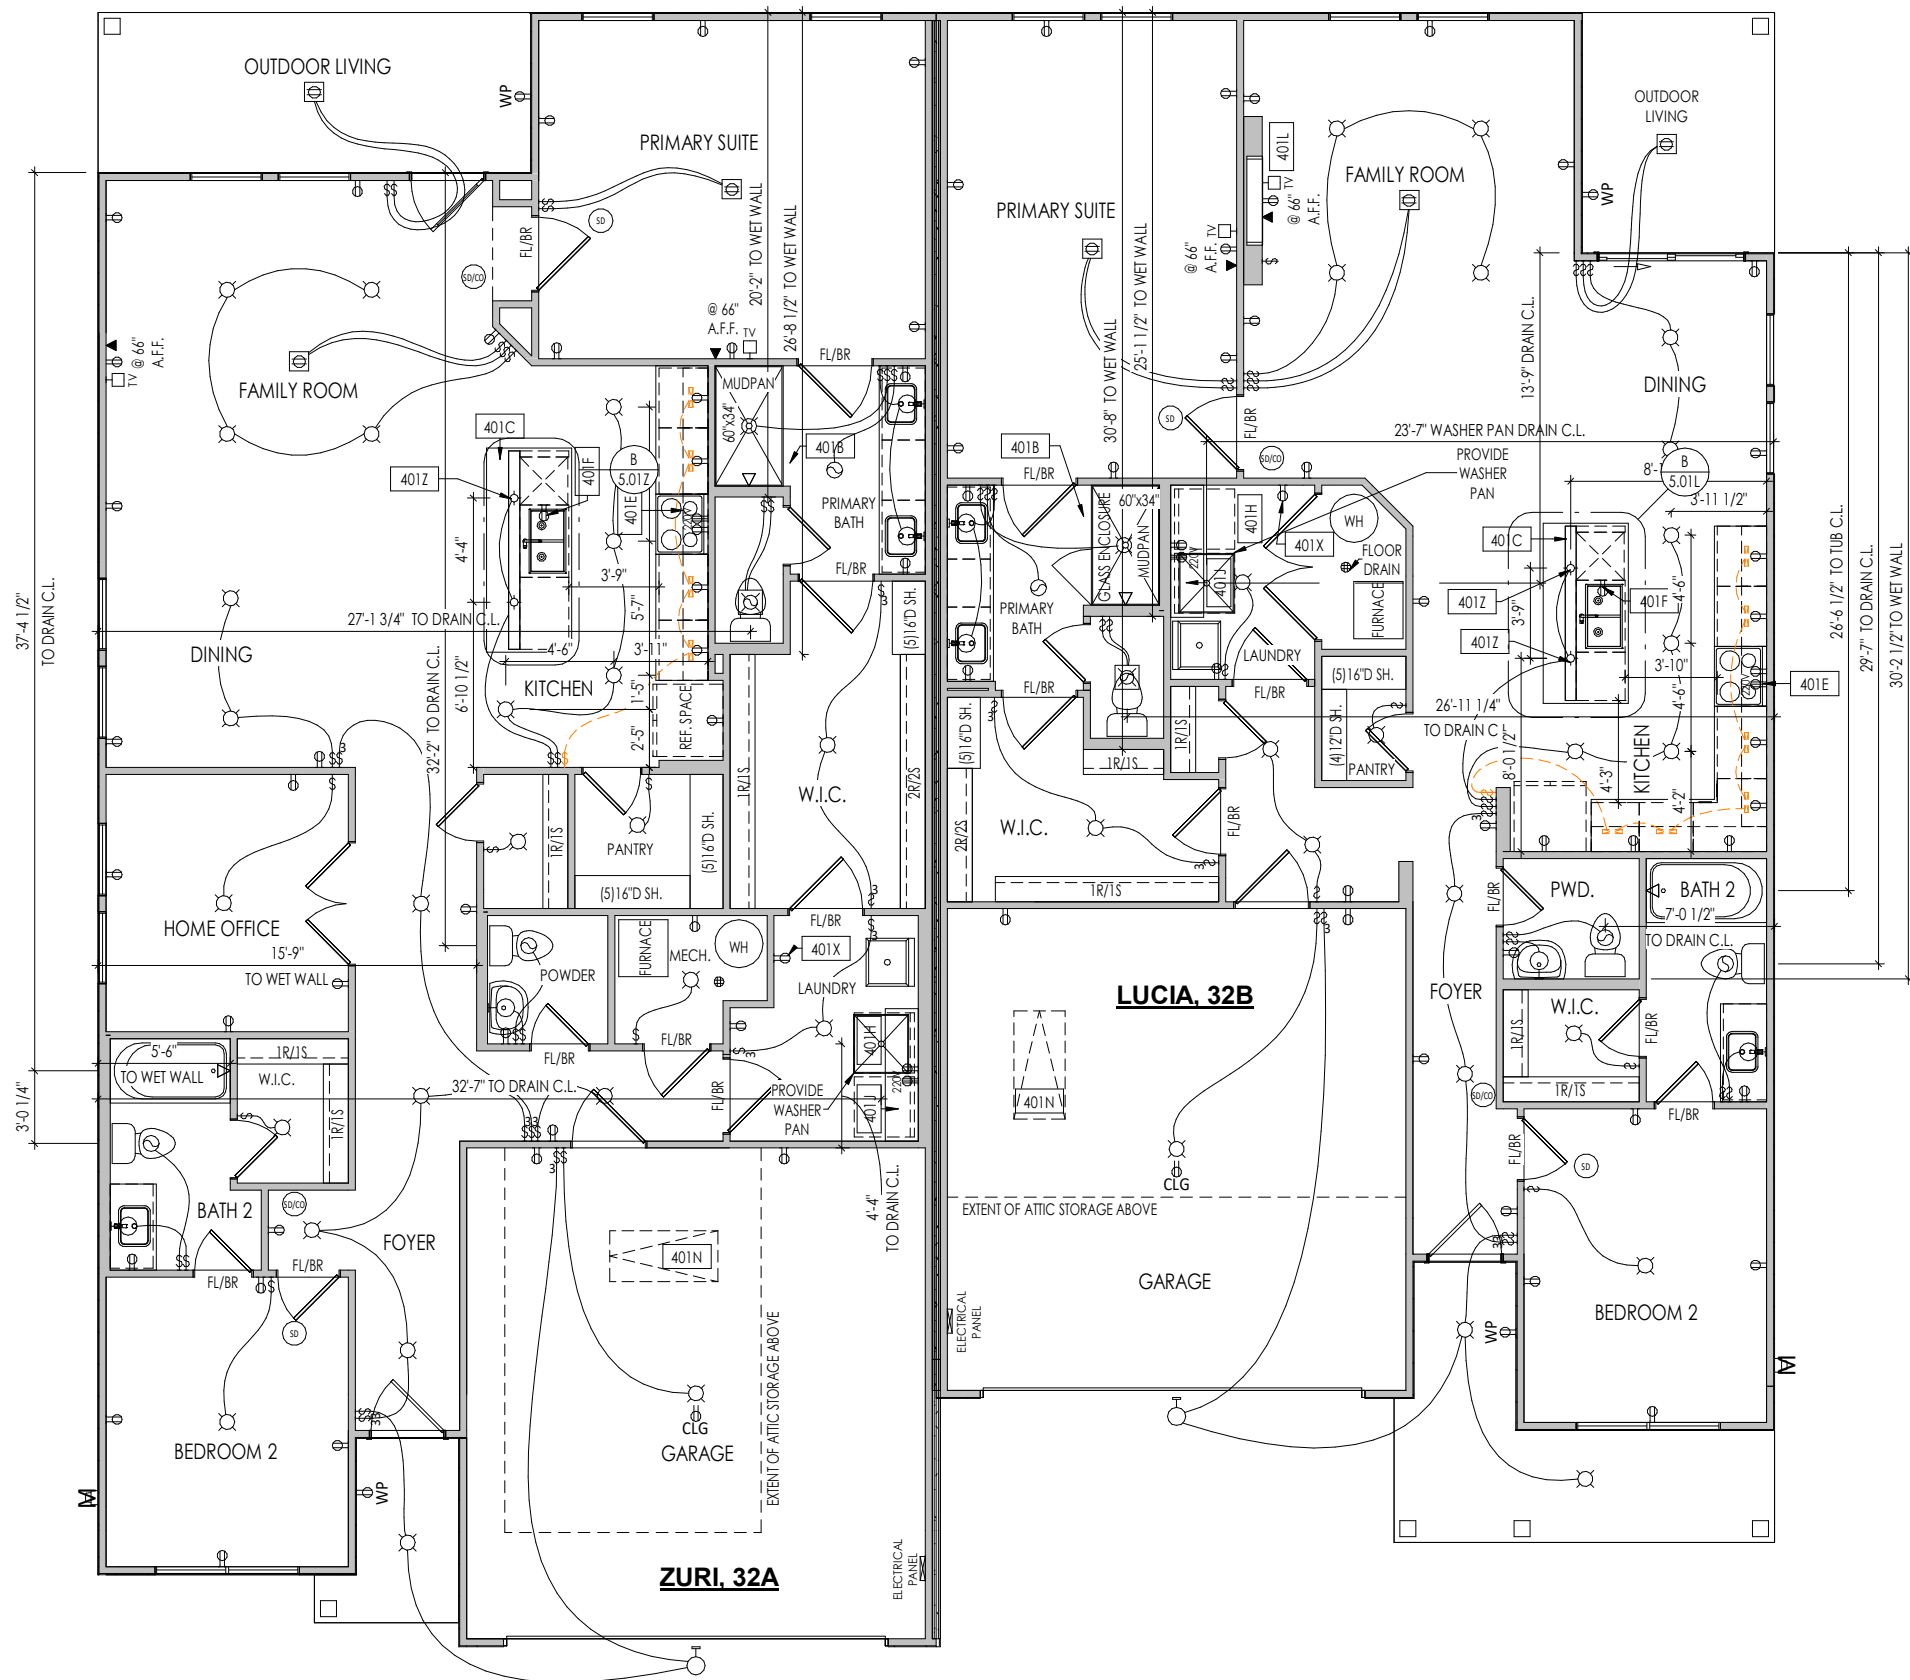

General Notes:

1. REFER TO SHEET ON.1 FOR GENERAL NOTES.

Key Notes:

402A	TO SWITCH OR LIGHT ABOVE
401E	OUTLET FOR RANGE HOOD/MICROWAVE HELD HIGH - DO NOT VENT TO EXTERIOR
401F	OUTLET FOR DISHWASHER + SWITCH FOR DISPOSAL LOCATED IN SINK CABINET
401G	OPT. UNDER CABINET LIGHTING - SEE SELECTIONS
401H	LOCATE WASHER TO LEFT OF DRYER
401J	UPPER WALL CABINETS OR 16\"
401K	22-1/2\"
401N	PULL DOWN ATTIC ACCESS STAIRS (25-1/2\"
401P	1x TRIM FOR FUTURE SCREEN ODL SYSTEM FOR STONE AND VINYL APPLICATIONS (NOT TO BE APPLIED AT POSTS/COLUMNS).
401R	SLOPE WALL EVEN WITH TOP OF STAIR STRINGER, RAILING ABOVE
401S	PRE-FABRICATED ELECTRIC FIREPLACE INSERT

MECHANICAL LEGEND

⊖ WALL OUTLET	⊙ CLG. MOUNTED LIGHT FIXT.	⊕ HOSE BIB
⊖ WEATHERPROOF GFCI OUTLET	⊙ SURFACE MOUNT DISC LIGHT OR RECESSED CEILING LIGHT, PER SPECS.	⊕ SHOWER HEAD
⊖ 220 VOLT OUTLET	⊙ WALL MOUNTED LIGHT FIXT.	⊕ GAS GAS HOOK UP
⊖ GFCI OUTLET	⊙ DOUBLE SPOTLIGHT FIXT.	⊕ FLOOR DRAIN
⊖ FLOOR OUTLET	⊙ DIRECTIONAL CAN LIGHT	⊕ SMOKE DETECTOR
⊖ COUNTER POP-UP OUTLET	⊙ PIN LIGHT	⊕ SMOKE DETECTOR/CO DETECTOR COMBINATION
⊖ SINGLE POLE SWITCH	⊖ WALL SCONCE @ 5'-6\"	⊕ EXHAUST FAN AND LIGHT COMBINATION
⊖ 3-WAY SWITCH	⊖ FLUORESCENT LIGHT	⊖ CLG. MTD. EXHAUST FAN
⊖ 4-WAY SWITCH	⊖ UNDER CABINET LIGHTING	⊖ DATA JACK
⊖ STAIR LIGHT		⊖ CABLE TELEVISION JACK
⊖ BLOCK, MOUNT, & SWITCH FOR FUTURE FAN/LIGHT COMBINATION (CENTER, UNLESS OTHERWISE NOTED)		

Space for Architect Seal

RESIDENCE FOR:
MARKET
2476-2478 BARTRAM LN
TRAILHEAD ACADIA

Job Number: TRA-00325-00	Drawing Date: 09/19/24	Coord Name: L. RAMLER	Coord Phone: 859.578.4212
House Name: ZURI + LUCIA Duplex			Contract Drawn By: KEB
Born on Date: 05/04/2021			CDs Drawn By: ALD
Series:			Plan No.:

Drees
HOMESSM

Copyright © 2021 (2021) The Drees Company. All Rights Reserved.
211 Grandview Drive, Fort Mitchell, KY 41017
Phone: [859] 578-4200

Sheet Information

4.01
First Floor Mechanical Plan

5/7/2025 4:21 PM

Autodesk Docs/Drees Architecture/TRAA-0032S-00 Zuri+Lucia Duplex Main.rvt



TYPICAL TRIM:

6" FASCIA
(ALL SIDES)

8" FRIEZE
(FRONT ONLY, UNLESS OTHERWISE NOTED)

General Notes:

1. REFER TO SHEET 0N.1 FOR GENERAL NOTES.
2. ROOFING MATERIAL PER SELECTIONS.
3. REFER TO SELECTIONS FOR STYLE OF GARAGE DOOR AND FRONT DOOR.

Key Notes:

602A	1x TRIM FOR FUTURE SCREEN ODL SYSTEM FOR STONE AND VINYL APPLICATIONS (NOT TO BE APPLIED AT POSTS/COLUMNS).
602B	XXX
601C	XXX
601D	XXX

Space for Architect Seal

RESIDENCE FOR:
MARKET

TRAILHEAD ACADIA

Job Number: TRAA-0032S-00	Drawing Date: 09/19/24	Coord Name: L. RAMLER	Coord Phone: 859.578.4212
House Name: ZURI + LUCIA Duplex			Contract Drawn By: KEB
			Series:
			Plan No.:
Born on Date: 05/04/2021	CDs Drawn By: ALD		



Sheet Information

6.01
Front Elevation

5/19/2024 11:15:47 AM