


General Notes

- REFER TO SHEET ON.1-ON.3 FOR JACKSONVILLE GENERAL NOTES, DESIGN CRITERIA, AND ADDITIONAL DESIGN INFORMATION.
- GROUND FAULT CIRCUIT INTERRUPTER (GFCI) OUTLETS TO BE INSTALLED PER NEC 2011.
- DISHWASHER TO BE ON GFCI CIRCUIT

- Key Notes**
- 1 22-½" x 36" ATTIC ACCESS.
 - 2 OUTLET IN CEILING.
 - 3
 - 4
 - 5
 - 6 DISPOSAL SWITCH. LOCATE IN SINK CABINET.
 - 7 LOCATION OF TANKLESS WATER HEATER
 - 8 PRE-FABRICATED FIREPLACE INSERT
 - 9 CUSTOM SHOWER. SEE DETAIL C/7.02 FOR MORE INFORMATION
 - 10 REFER TO JOBDOC ON DREESBUILD FOR FINAL KITCHEN CABINET LAYOUT
 - 11 LOCATE WASHER TO THE LEFT OF DRYER
 - 12 16" DEEP SHELF AT 5'-7" A.F.F
 - 13 ELECTRICAL PANEL LOCATION
 - 14 DEDICATED IRRIGATION OUTLET
 - 15 VENTHOOD/MICROWAVE OUTLET HELD HIGH, VENT TO EXTERIOR

MECHANICAL LEGEND	
◀ PHONE JACK	○ FLUORESCENT LIGHT
⬤ HOME OFFICE OUTLET	≡ UNDER CABINET LIGHTING
Ⓛ DATA OUTLET	⊗ CLG. MOUNTED LIGHT FIXT.
Ⓜ PROJECTOR ROUGH-IN	⊙ WALL MOUNTED LIGHT FIXT.
Ⓜ ENTERTAINMENT CENTER OUTLET	⊙ SUFACE MOUNT DISC LIGHT
⊙ WALL OUTLET	⊙ OR RECESSED CEILING LIGHT, PER SPECS.
⊙ WEATHERPROOF GFCI OUTLET	⊙ DOUBLE SPOTLIGHT FIXT.
⊙ 220 OUTLET	⊙ DIRECTIONAL CAN LIGHT
⊙ GROUND FAULT OUTLET	⊙ WALL SCONCE @ 5'-6" A.F.F
⊙ FLOOR OUTLET	⬤ STAIR LIGHT
Ⓜ CABLE TELEVISION JACK	⊙ CLG. MTD. EXHAUST FAN
Ⓜ SINGLE POLE SWITCH	⊙ WALL MTD. EXHAUST FAN
Ⓜ 3-WAY SWITCH	⊙ SMOKE DETECTOR
Ⓜ 4-WAY SWITCH	⊙ HOSE BIB
Ⓜ STEREO SPEAKER	⊙ SHOWER HEAD
Ⓜ BLOCK MOUNT. & SWITCH FOR FUTURE FAN/LIGHT COMBO (CENTER, UNLESS OTHERWISE NOTED)	⊙ GAS HOOK UP
Ⓜ EXHAUST FAN AND LIGHT COMBINATION	⊙ FLOOR DRAIN
	⊙ SMOKE DETECTOR/CO DETECTOR COMBINATION

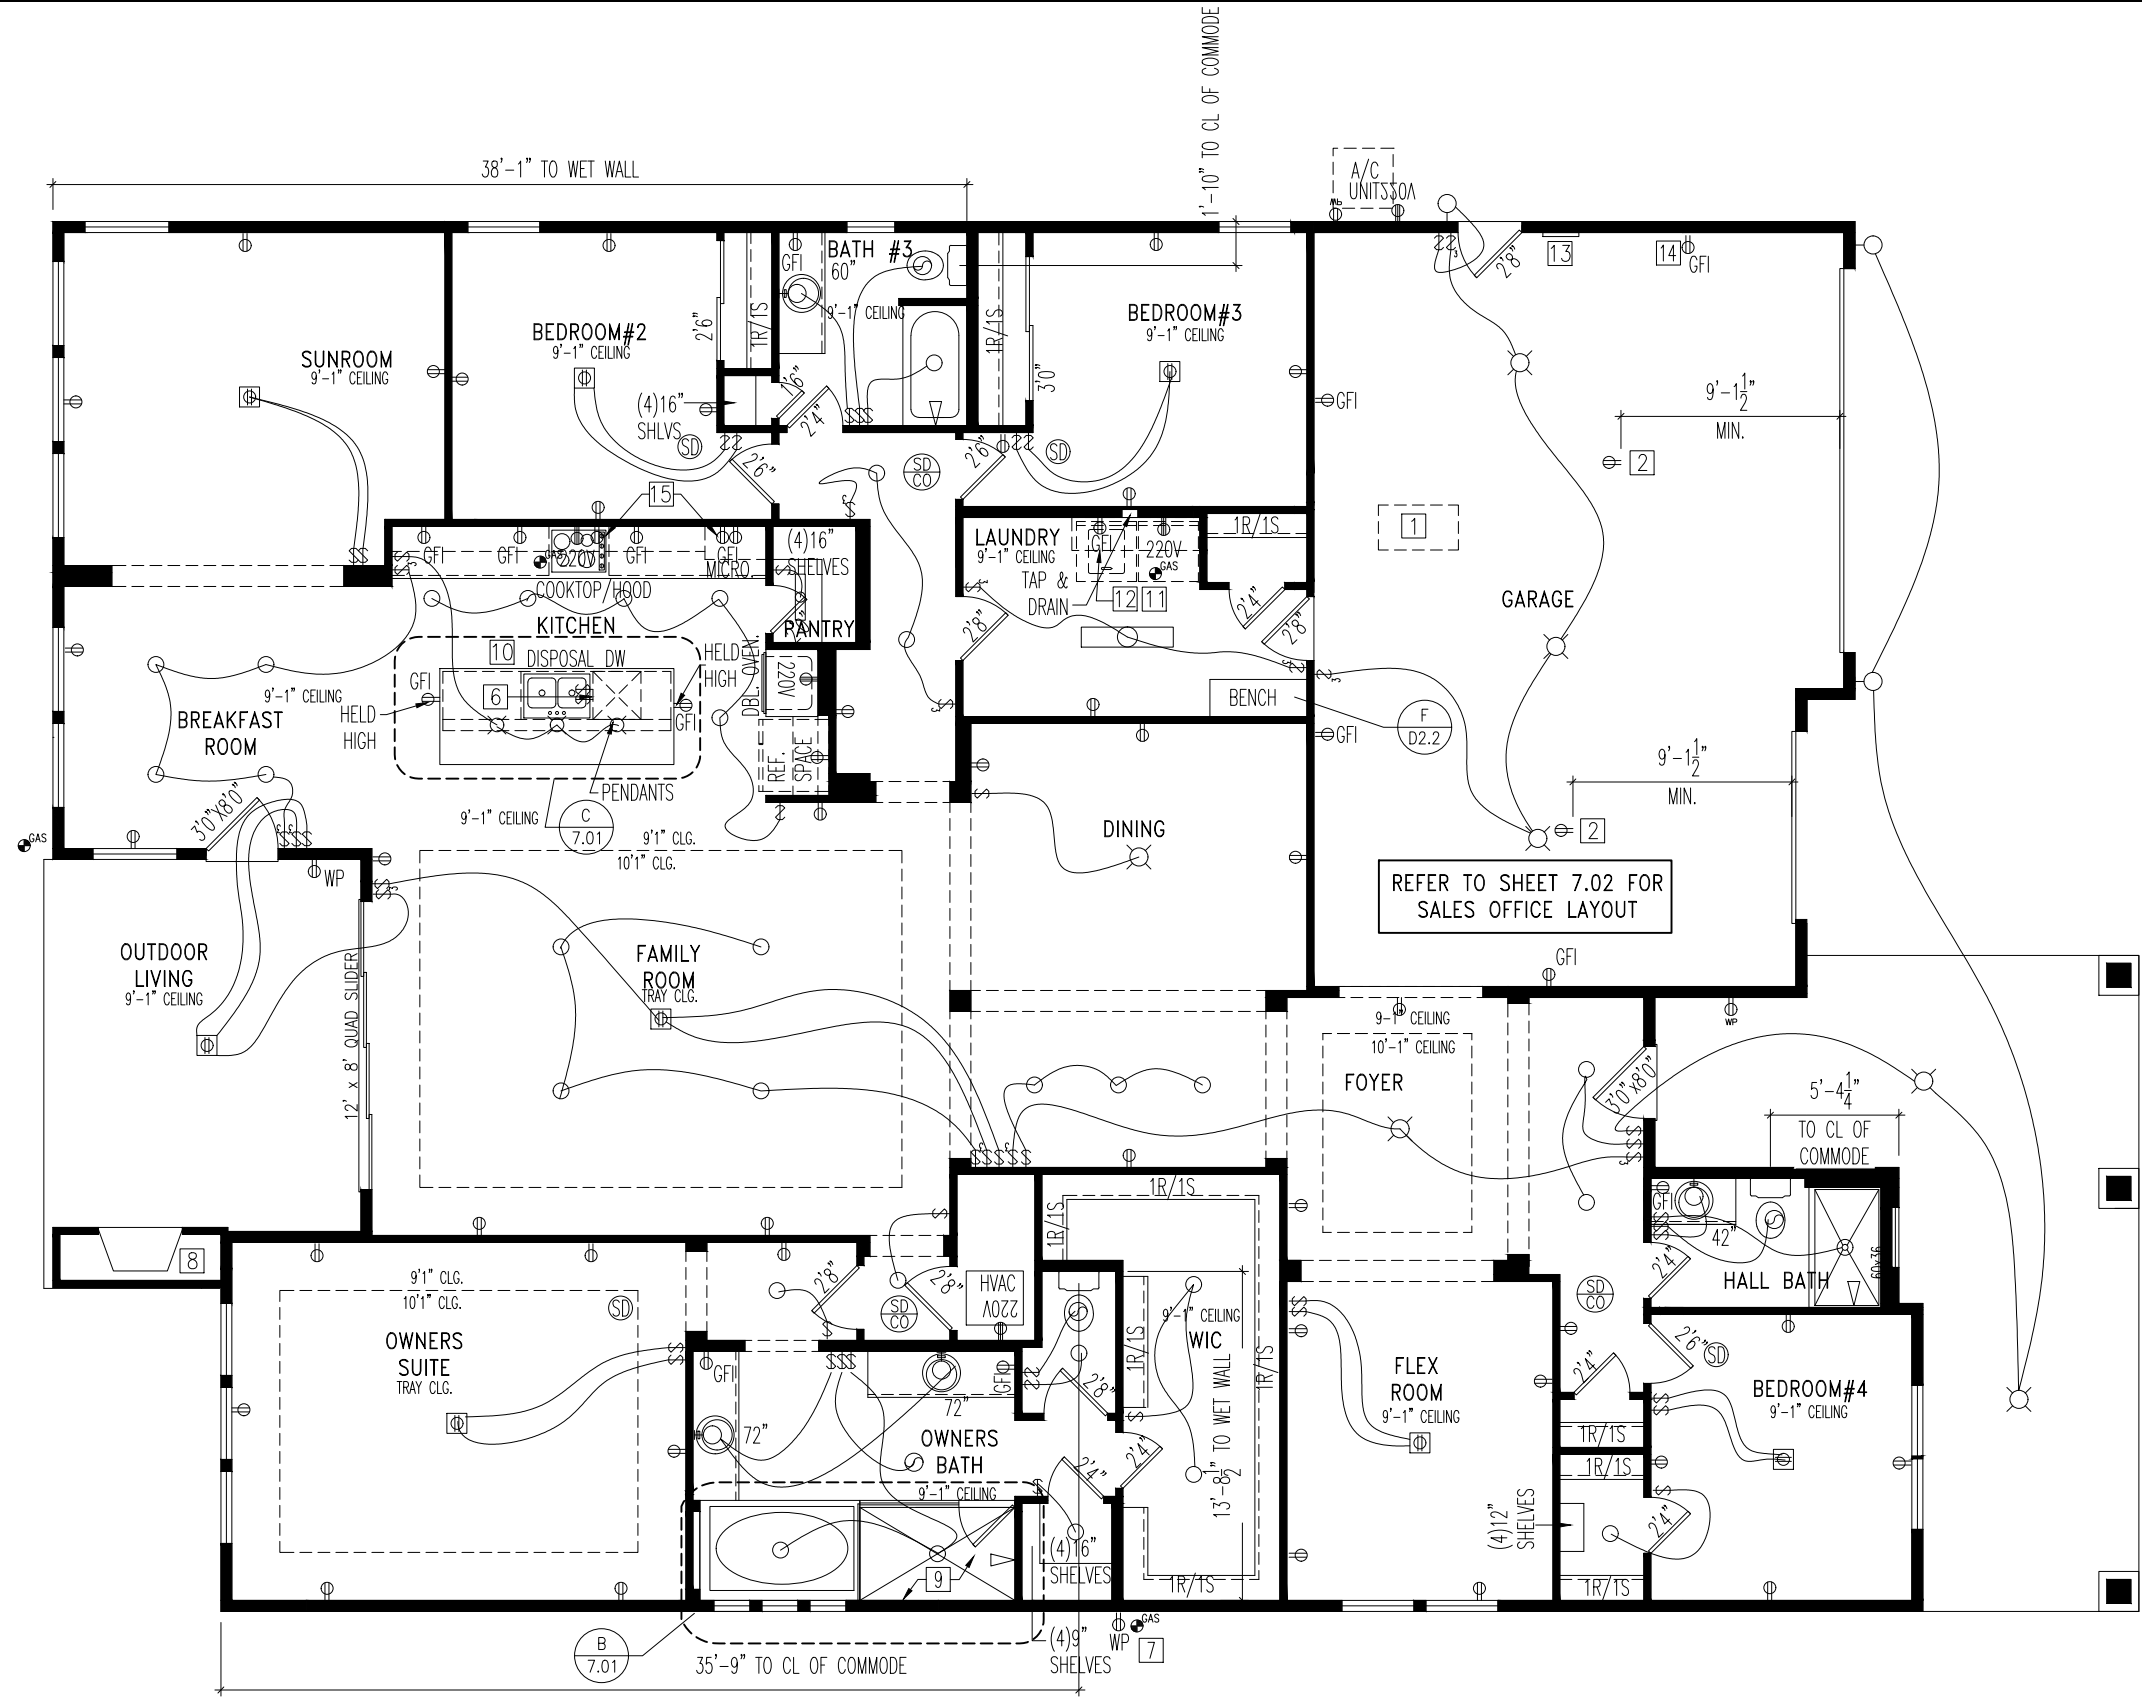

REISSUED: 6/30/2020



The Drees Company
9452 Phillips Hwy, Suite 4 Jacksonville, FL 32256 PH: (904) 399-2501
CRC1329710

Copyright © 2013, (2017) The Drees Company. All Rights Reserved. No portion of this material may be reproduced in any form or by any means, including photocopying, without the express written permission of the Drees Company. The Drees Company will vigorously prosecute any unauthorized use of this material.

House:
PALMETTO

Series:
LEGACY

Plan No.:
PLAN_NM

Std. Drawn By: JRT
Std. Chk. By: ARC
Std. Date: 03-13-13
Date of Last Rev: 6-27-13 JRT

Sheet Description: **FIRST FLOOR MECHANICAL PLAN ELEVATION "G"**

SCALE: 1/8" = 1'-0"

Contract Drawn By: DWW
Phone #: DWW_PH
Coordinator's Name: GREG PIEPER
Coordinator's Phone #: 859-578-4355

Original Site Specific Dwg. & Effective Change Order Date:


5/7/2020

TRM-0578-00 plan.dwg Jun 30, 2020 - 10:02am

Subdivision: TRAILMARK
Job #: TRM-0578-00
Customer Name: MODEL
Job Address: TBD


Sheet No.

4.01

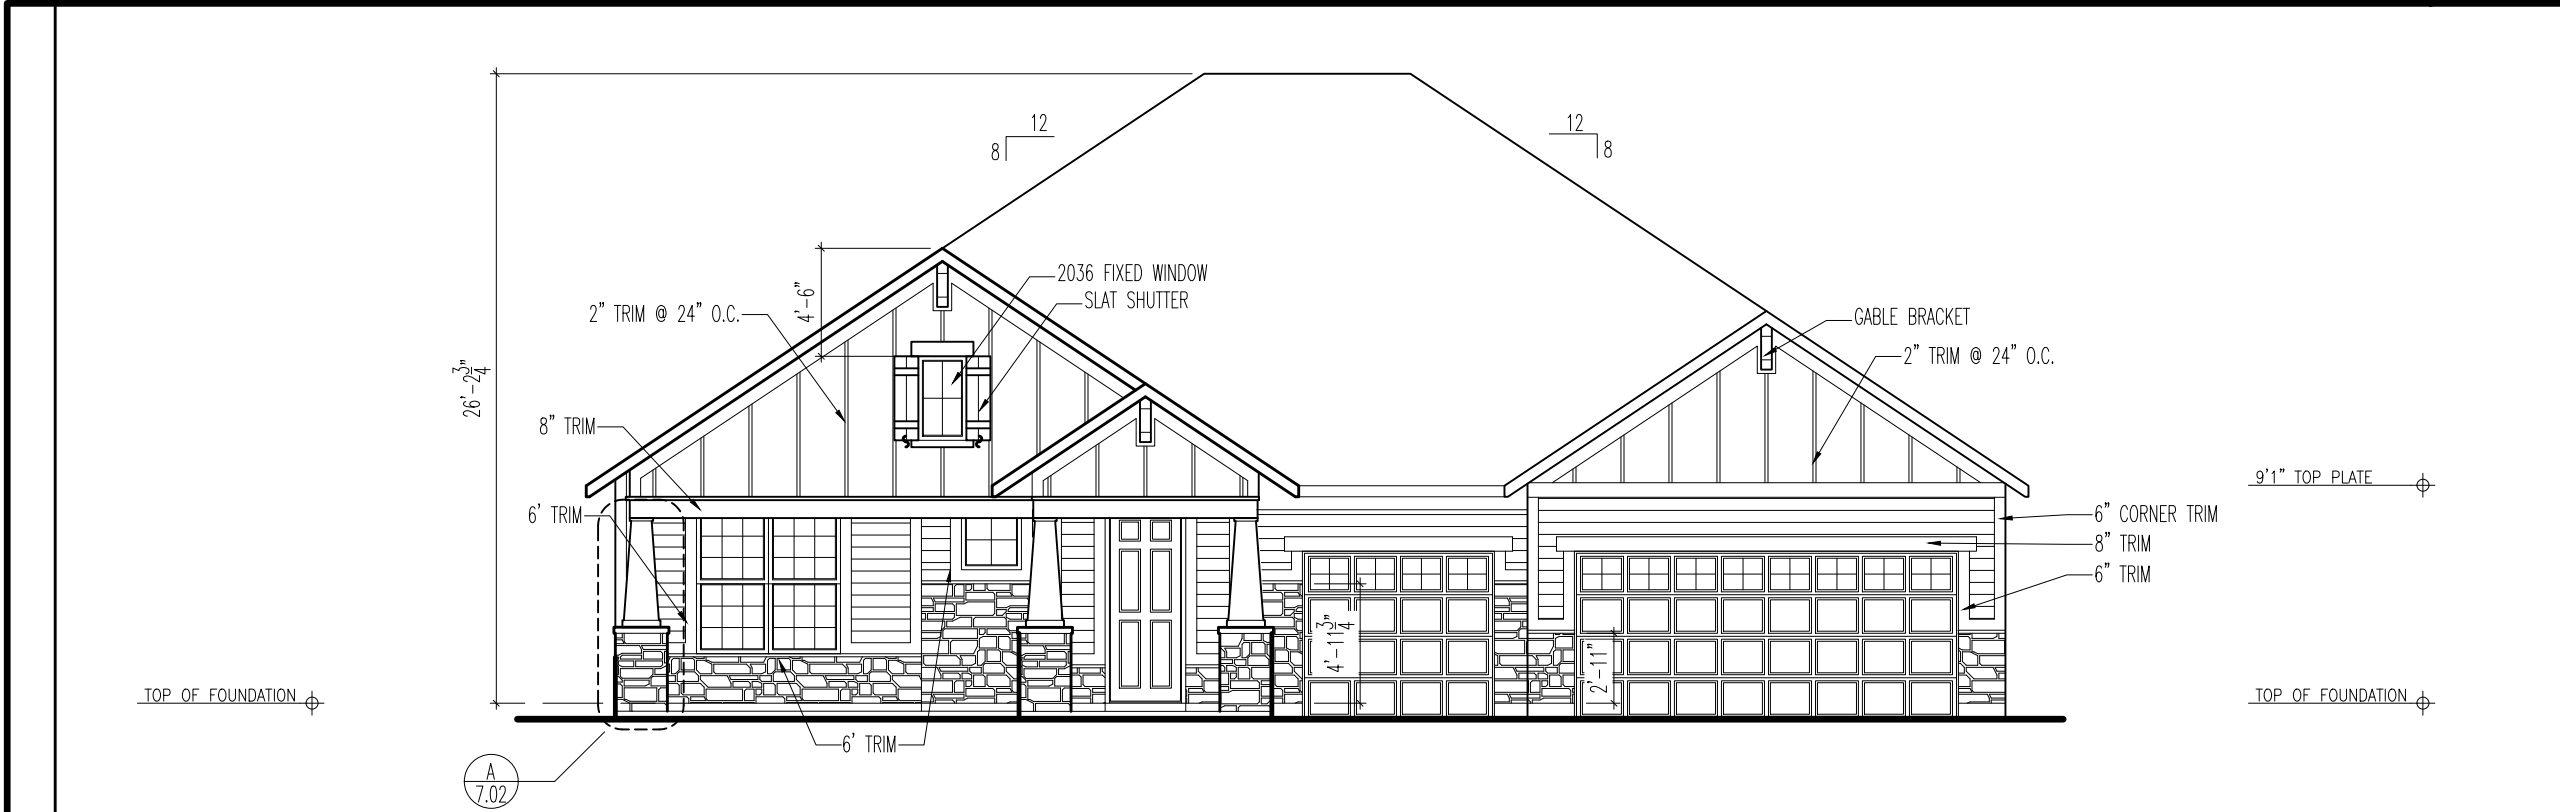

FRONT ELEVATION

SCALE: 1/8" = 1'-0"

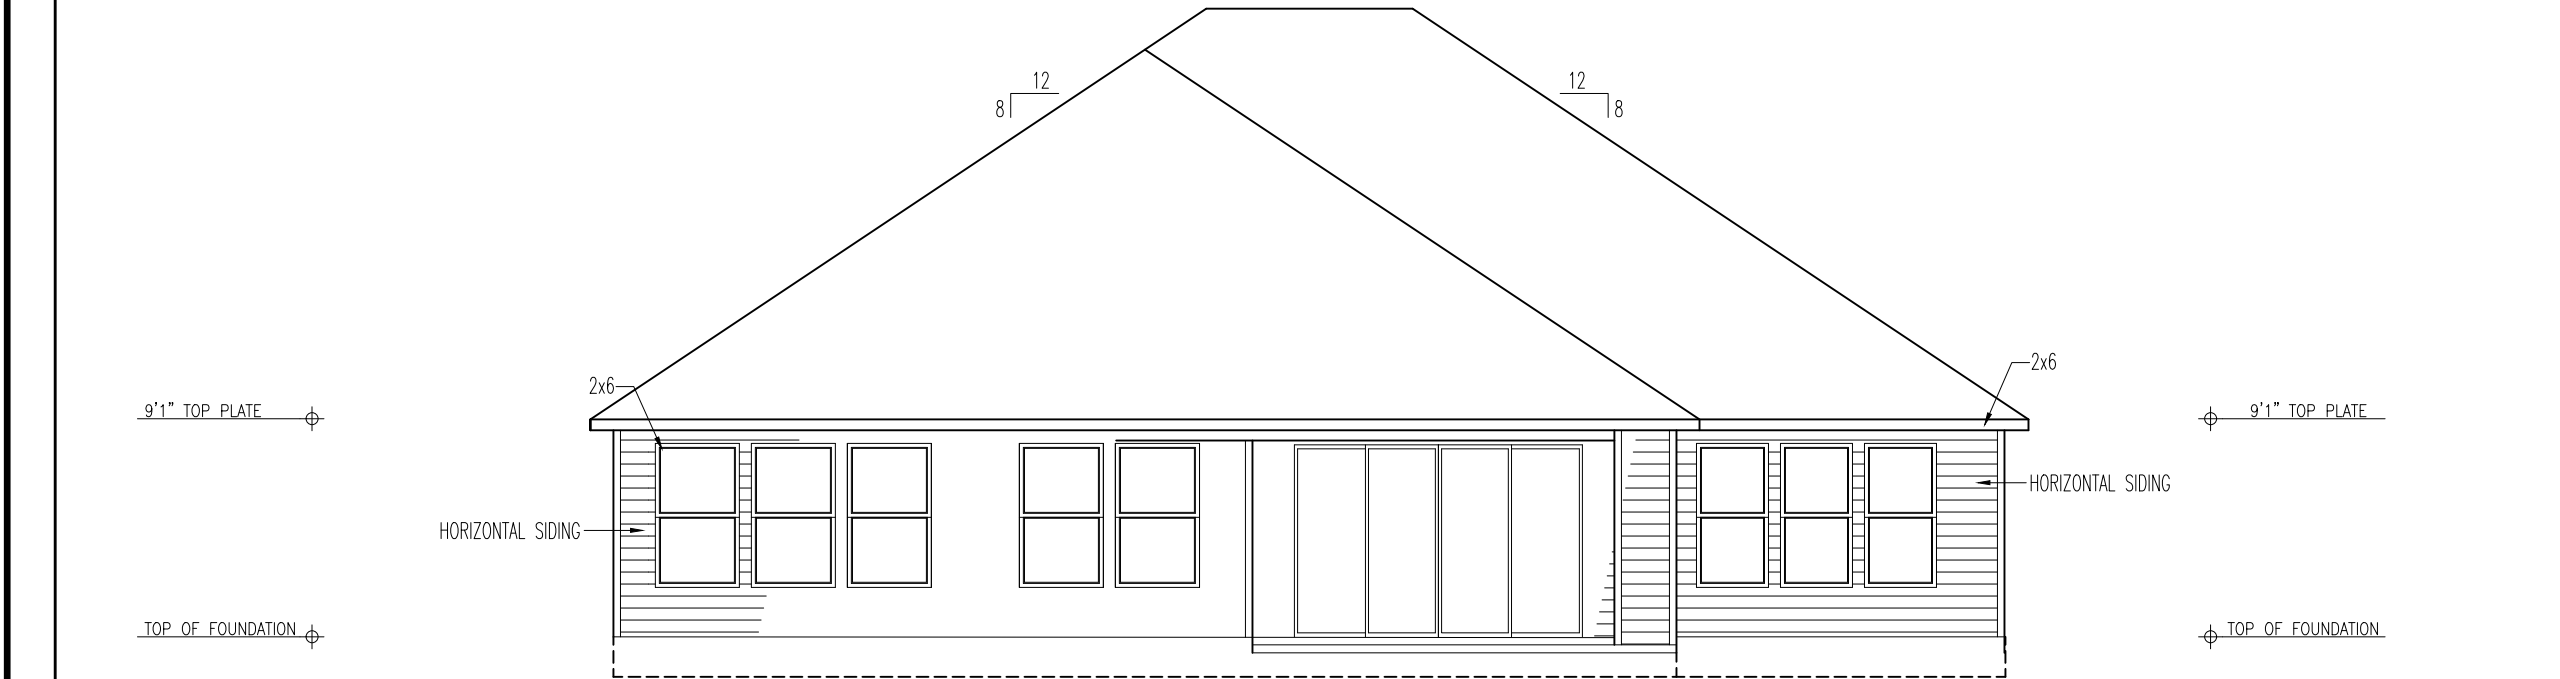

REAR ELEVATION

SCALE: 1/8" = 1'-0"

General Notes

- REFER TO SHEET ON.1-ON.3 FOR JACKSONVILLE GENERAL NOTES, DESIGN CRITERIA, AND ADDITIONAL DESIGN INFORMATION.
- REFER TO SHEET SC-02 FOR MOULDED MILLWORK SCHEDULE
- ROOFING PER SUBDIVISION SPECIFICATIONS

Key Notes

- 1
- 2 --
- 3 --
- 4 --
- 5 --
- 6 --
- 7 --
- 8 --
- 9 --
- 10
- 11
- 12
- 13
- 14
- 15

BRICK and STONE
LINTEL SCHEDULE

	SPAN	LINTEL SIZE
*BRICK	Up to 6'-0"	L3 1/2 x 3 1/2 x 1/4
	Up to 8'-3"	L5 x 3 1/2 x 3/16
	Up to 9'-3"	**PER DESIGN
	Up to 16'-3"	**PER DESIGN
*STONE	Up to 6'-0"	L4 x 3 1/2 x 1/4
	Up to 8'-3"	L5 x 3 1/2 x 3/16
	Up to 9'-3"	**PER DESIGN
	Up to 16'-3"	**PER DESIGN

All Lintels: 4" Minimum bearing required each end
* Brick is based on 40psf and Stone is based on 60psf
** Any lintels not described by the above parameters shall be specifically designed.

Contract Revisions: (#, Date, By, Description)

i
ii
iii
iv

Subdivision:	TRAILMARK	Sheet No.
Job #:	TRM-0578-00	6.01
Customer Name:	MODEL	
Job Address:	TBD	



The Drees Company

9452 Phillips Hwy, Suite 4 Jacksonville, FL 32256 PH: (904) 399-2501

Copyright © 2013, (2017) The Drees Company. All Rights Reserved. No portion of this material may be reproduced in any form or by any means, including photocopying, without the express written permission of the Drees Company. The Drees Company will vigorously prosecute any unauthorized use of this material.

House:

PALMETTO

Series:
LEGACY

Plan No.:
PLAN_NM

Std. Drawn By: JRT

Std. Chk. By: ARC

Std. Date: 03-13-13

Date of Last Rev: 6-27-13 JRT

Sheet Description:

SCALE: 1/8" = 1'-0"

FRONT ELEVATION & DETAILS
ELEVATION "G"

Contract Drawn By:

DWW

Phone #:

DWG_PH

Coordinator's Name:

GREG PIEPER

Coordinator's Phone #:

859-578-4355

TRM-0578-00 plan.dwg May 07, 2020 - 3:48pm

Original Site Specific Dwg. & Effective Change Order Date:

5/7/2020