


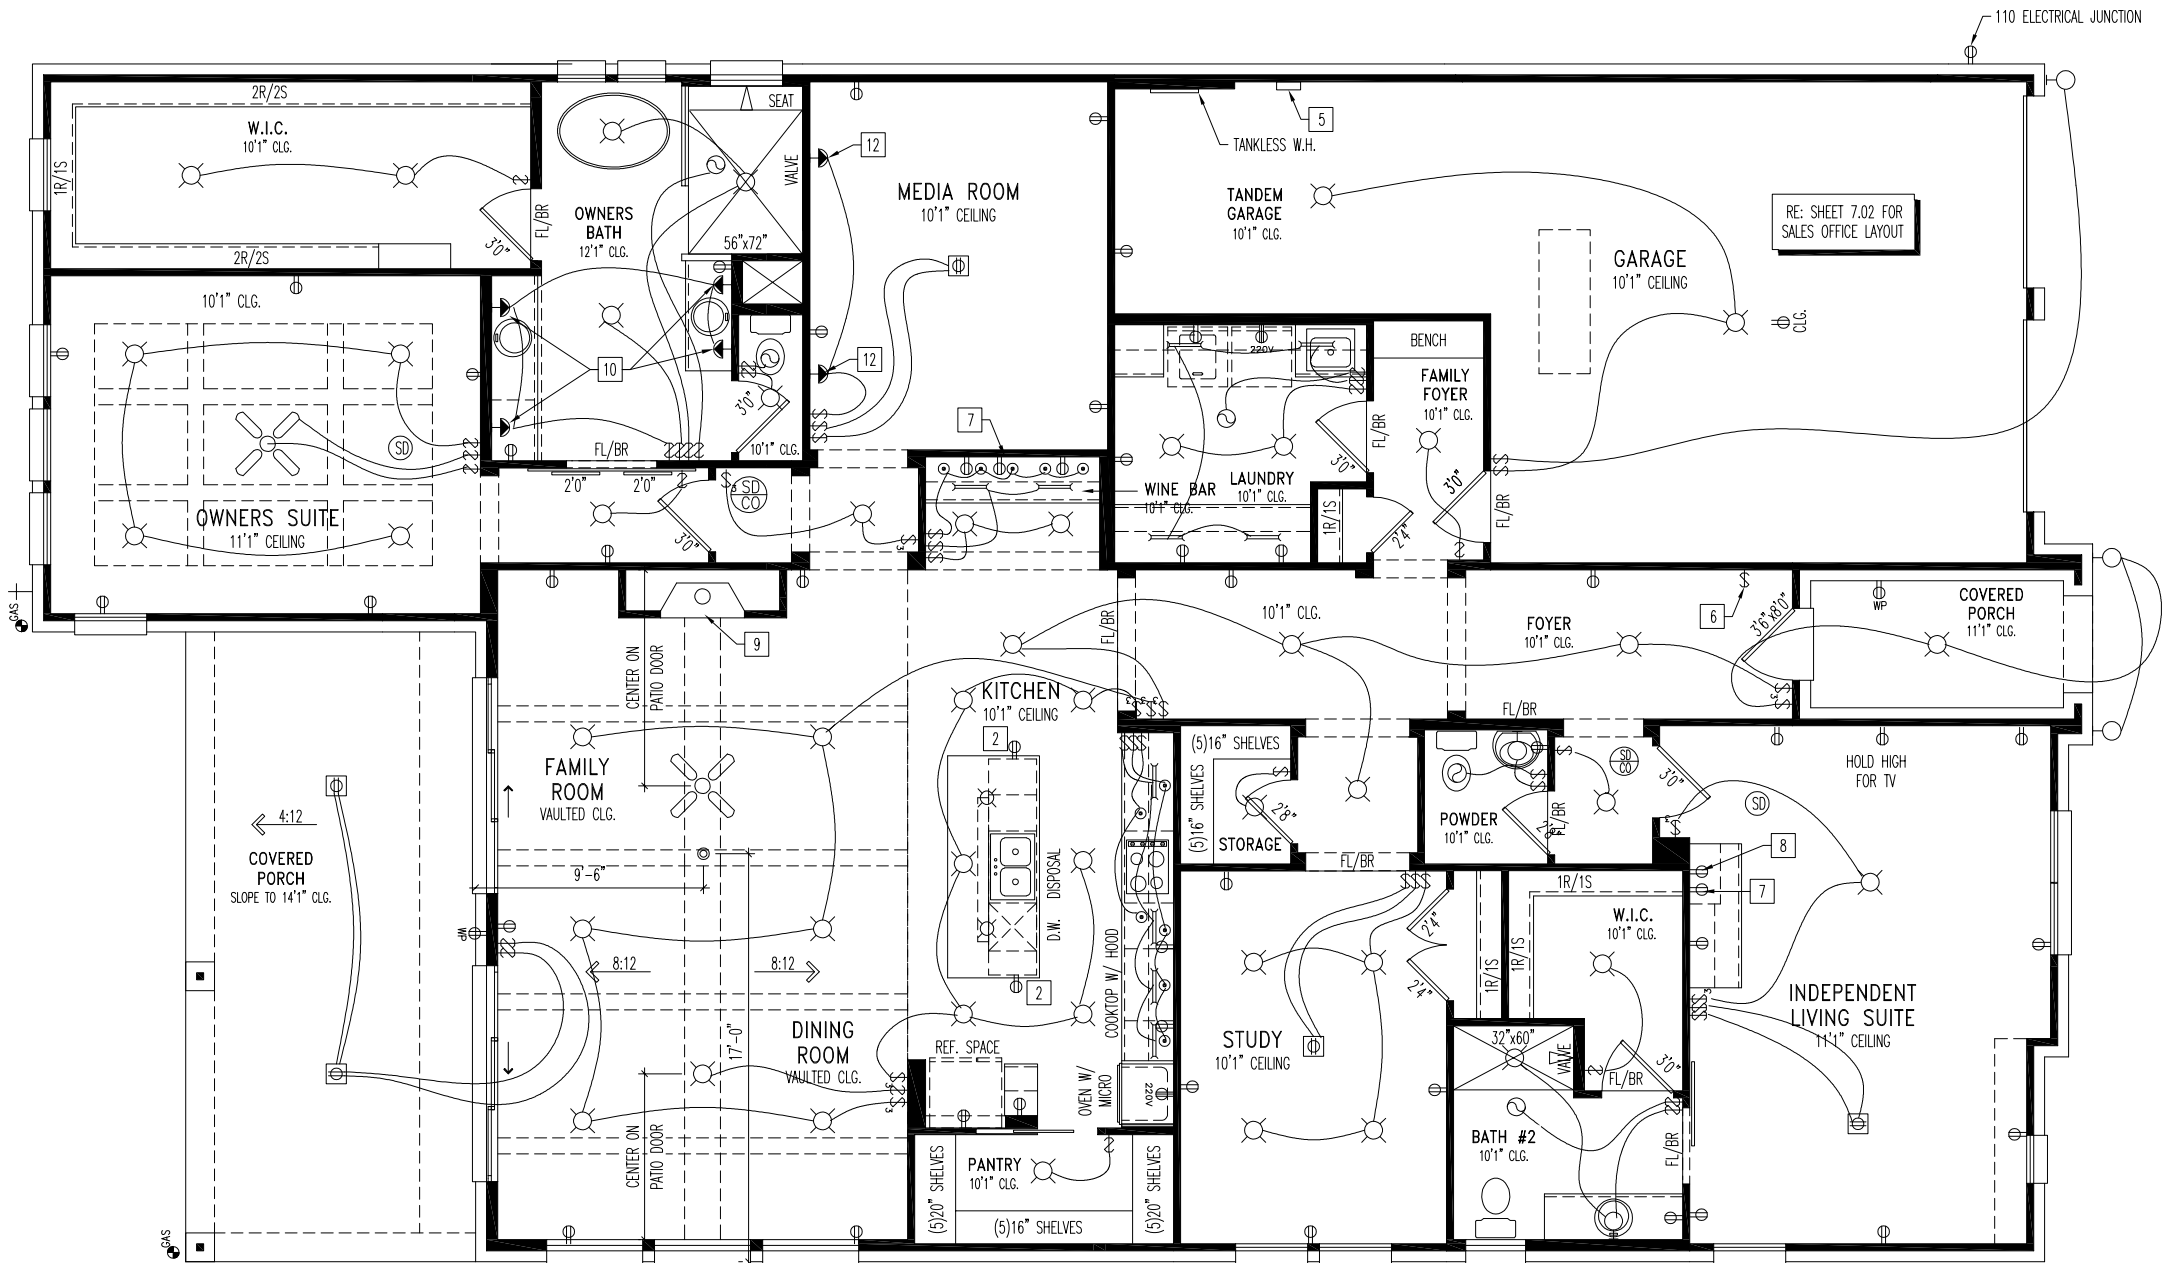

General Notes

1. REFER TO SHEET ON.1 FOR GENERAL NOTES.

Key Notes

- 1 TO LIGHT OR SWITCH
- 2 HOLD OUTLET HIGH ON ISLAND
- 3 OUTLET IN CEILING
- 4 OUTLET @ 45° A.F.F.
- 5 TIMER FOR ALL EXTERIOR LIGHTS
- 6 WHOLE HOUSE LIGHT SWITCH
- 7 UNDERCOUNTER OUTLET FOR FRIDGE
- 8 OUTLET FOR MICROWAVE HELD HIGH
- 9 FIREBOX RAISED 12"
- 10 CENTER OF SCONCES SET AT 5'4" A.F.F. AND 6" OFF WALL
- 11 --
- 12 CENTER OF SCONCES SET AT 6' A.F.F. AND 3'1" OFF WALL

Mechanical Legend

PHONE JACK	FLUORESCENT LIGHT
HOME OFFICE OUTLET	UNDER CABINET LIGHTING
DATA OUTLET	CLG. MOUNTED LIGHT FIXT.
PROJECTOR ROUGH-IN	WALL MOUNTED LIGHT FIXT.
ENTERTAINMENT CENTER OUTLET	SURFACE MOUNT DISC LIGHT OR RECESSED CEILING LIGHT PER SPECS.
WALL OUTLET	DOUBLE SPOTLIGHT FIXT.
WEATHERPROOF OUTLET	DIRECTIONAL CAN LIGHT
220 OUTLET	PIN LIGHT
GROUND FAULT OUTLET	WALL SCONCE @ 5'-6" A.F.F.
FLOOR OUTLET	STAIR LIGHT
CABLE TELEVISION JACK	CLG. INTD. EXHAUST FAN
SINGLE POLE SWITCH	WALL INTD. EXHAUST FAN
3-WAY SWITCH	SMOKE DETECTOR
4-WAY SWITCH	HOSE BIB
BLOCK, MOUNT, & SWITCH FOR FUTURE FAN/LIGHT COMBINATION (CENTER, UNLESS OTHERWISE NOTED)	SHOWER HEAD
EXHAUST FAN AND LIGHT COMBINATION	GAS HOOK UP
FLOOR DRAIN	CO DETECTOR
	SMOKE DETECTOR/CO DETECTOR COMBINATION



DREES CUSTOM HOMES L.P.
6225 STATE HIGHWAY 161, SUITE 400, IRVING, TX. 75038
(972) 953-4500
Copyright © 2018, (2016) The Drees Company. All Rights Reserved. No portion of this material may be reproduced in any form or by any means, including photocopying, without the express written permission of the Drees Company. The Drees Company will vigorously prosecute any unauthorized use of this material.

House:
BRYNLEE II
Series:
Plan No.:
2805

Std. Drawn By: STD_BY
Std. Chk. By: ARC
Std. Date: STD_DATE
Date of Last Rev: REV_DATE

Sheet Description:
**FIRST FLOOR MECHANICAL PLAN
ELEVATION "J"**

SCALE: 1/8" = 1'-0"

Contract Drawn By: **BRIAN W.**
Phone #: **N/A**
Coordinator's Name: **LISA C.**
Coordinator's Phone #: **859 578-4322**
VR3-0018-11.dwg Jan 30, 2019 - 4:29pm


Original Site Specific Dwg. & Effective Change Order Date:

05/07/18

Subdivision: **IRIDIAN**
Job #: **VIR3-0018-11**
Customer Name: **MODEL**
Job Address: **4804 CYPRESS THORN DRIVE**

Sheet No.

4.01

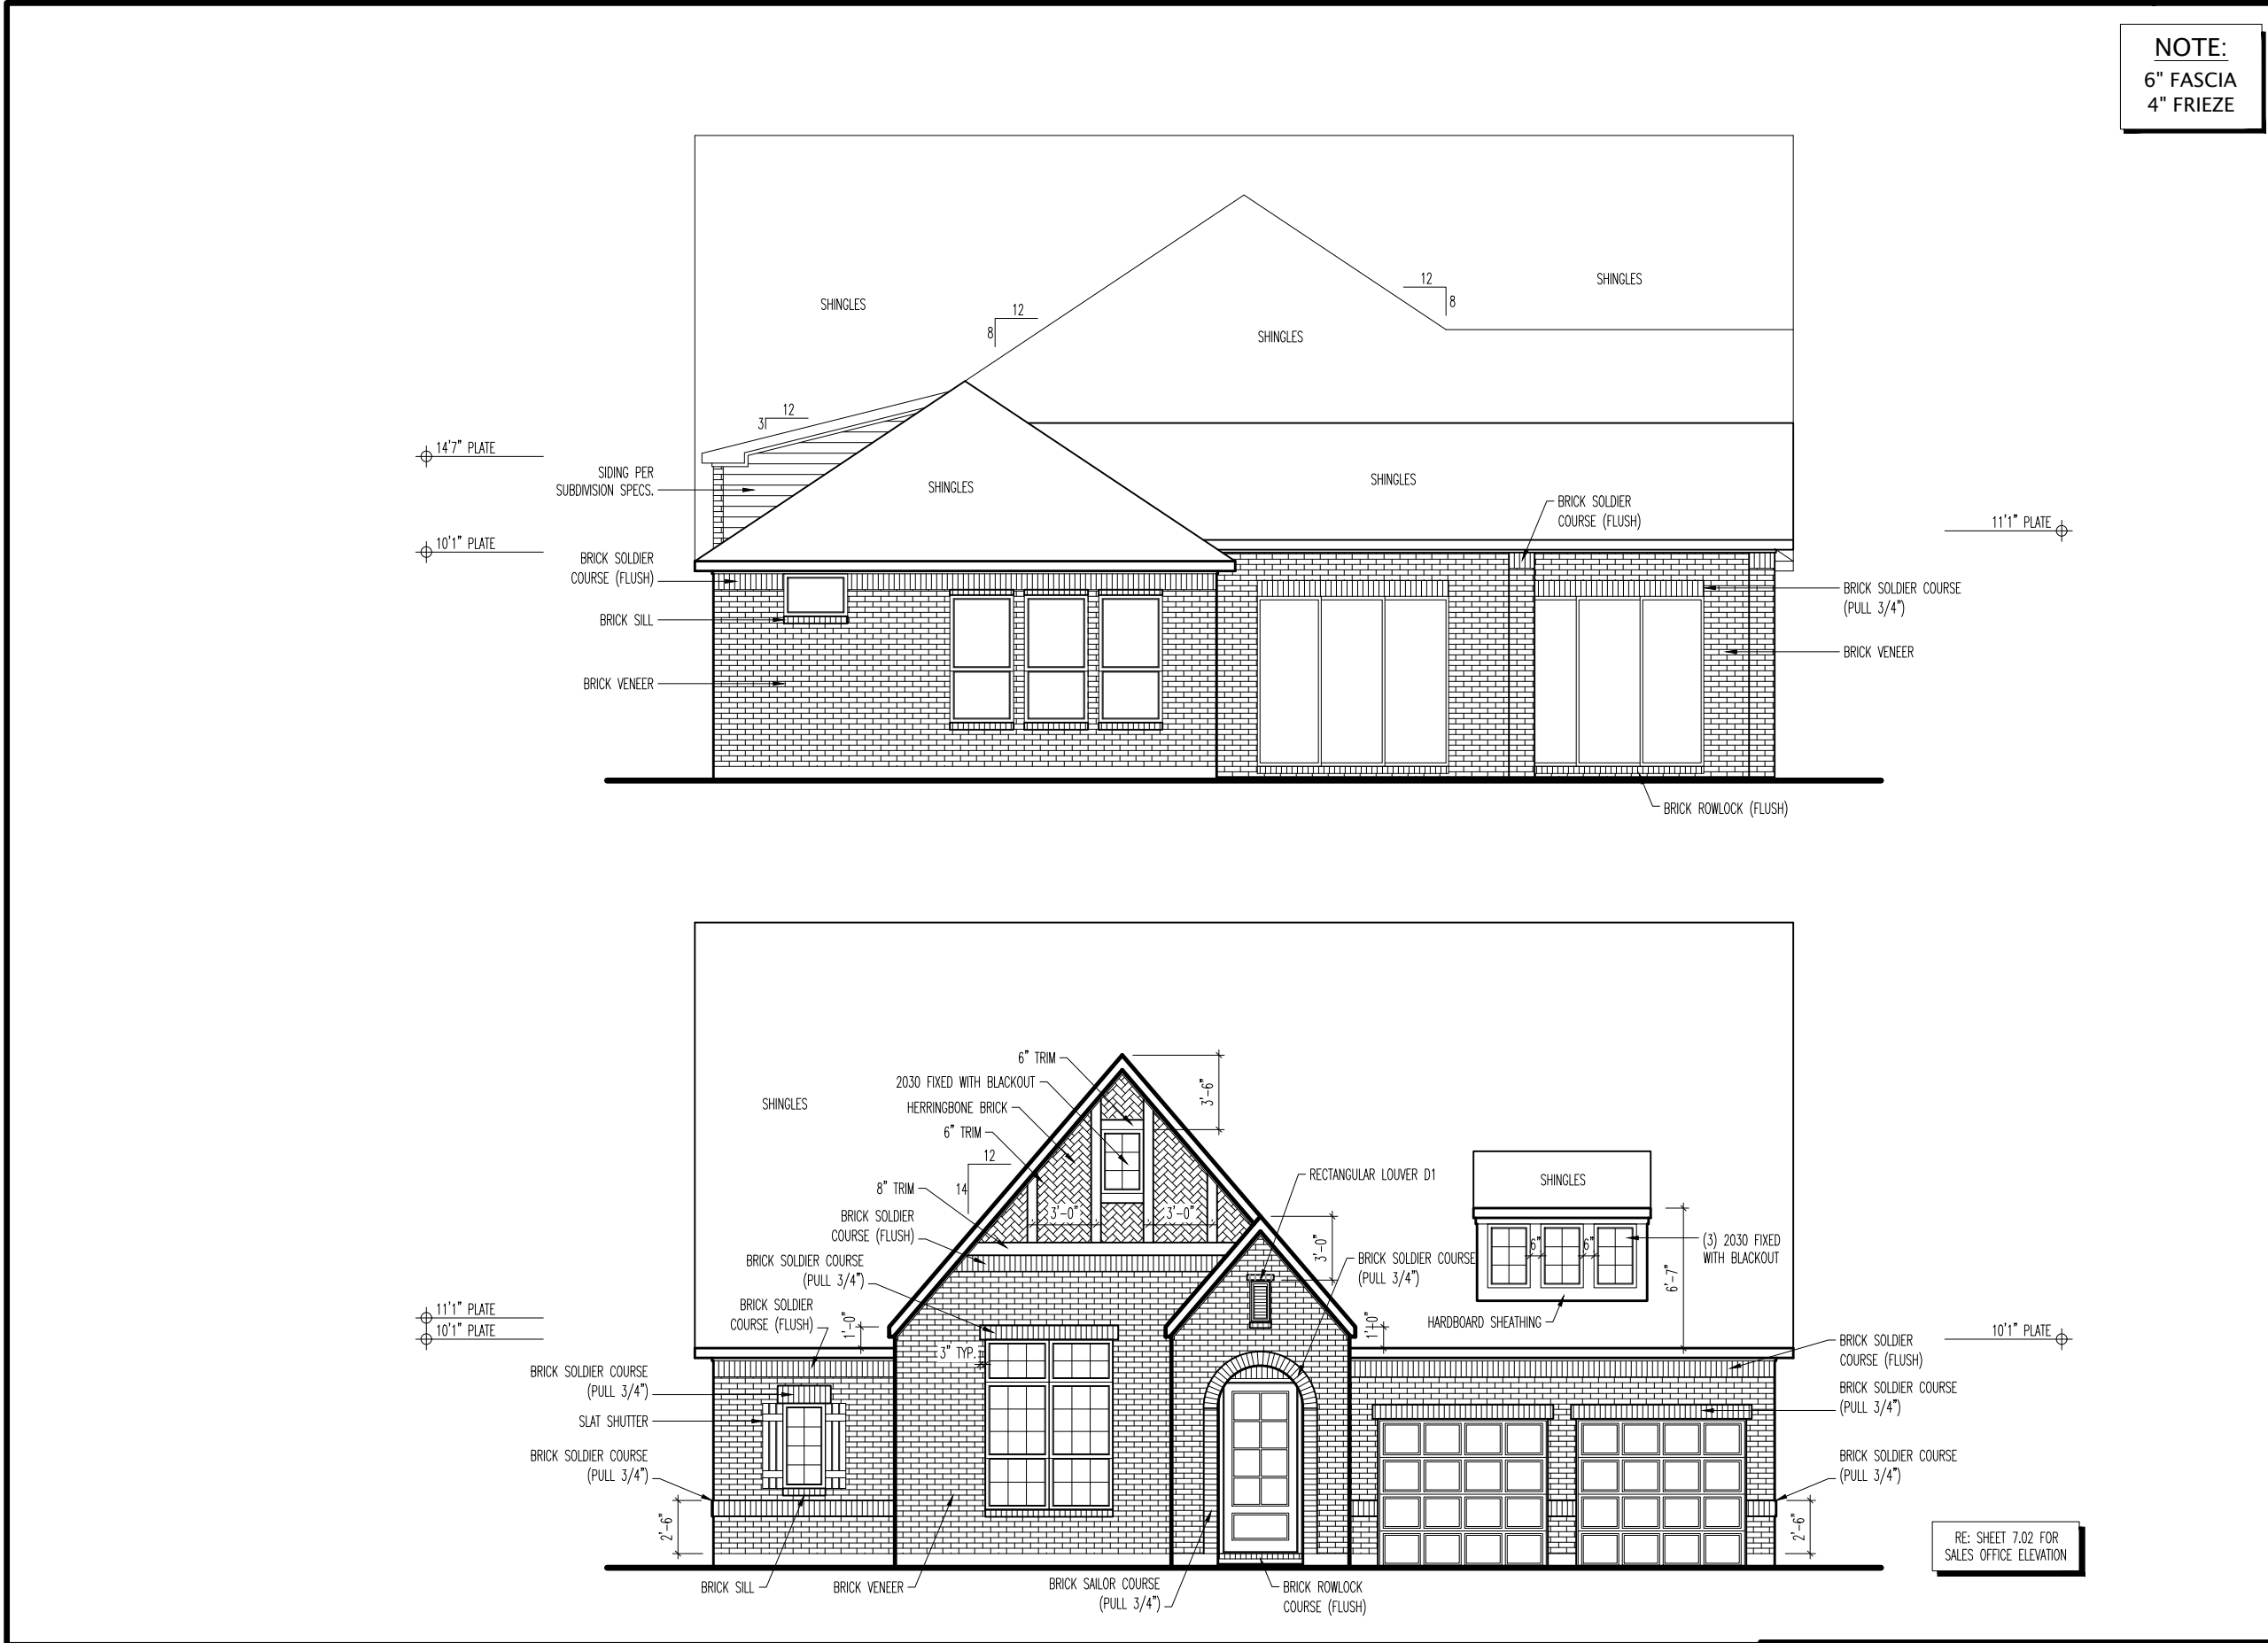

NOTE:
6" FASCIA
4" FRIEZE

General Notes

1. REFER TO SHEET ON.1 FOR GENERAL NOTES.
2. ROOFING MATERIAL PER SPECIFICATIONS.
3. FOUNDATIONS OF EXTERIOR WALLS OR PIERS EXPOSED MORE THAN TEN INCHES ABOVE THE ADJACENT GROUND LEVEL SHALL BE CLAD IN THE PRIMARY EXTERIOR FINISH MATERIAL, SUCH AS BRICK, STONE, OR STUCCO, OR STAINED TO COMPLEMENT THE PRIMARY EXTERIOR FINISH MATERIAL.

Key Notes

1

--

2

--

3

--

4

--

5

--

6

--

7

--

8

--

9

--

10

--

BRICK and STONE LINTEL SCHEDULE

	SPAN	36" HIGH	48" HIGH	LINTEL SIZE	WINDOW ABOVE
*BRICK	Up to 6'-0"	---	---	L3½ x 3½ x ¼	---
	Up to 8'-3"	---	---	L5 x 3½ x ⅝	---
	Up to 9'-3"	---	---	L6 x 4 x ⅝	L7 x 4 x ⅝
	Up to 16'-3"	L7 x 4 x ⅝	L8 x 4 x ½	L8 x 4 x ½	**per Design
*STONE	Up to 6'-0"	---	---	L4 x 3½ x ¼	---
	Up to 8'-3"	---	---	L5 x 3½ x ⅝	---
	Up to 9'-3"	---	L6 x 4 x ⅝	L7 x 4 x ⅝	**per Design
	Up to 16'-3"	---	L8 x 4 x ½	**per Design	**per Design

All Lintels: 4" Minimum bearing required each end
* Brick is based on 40psf and Stone is based on 60psf
** Any lintels not described by the above parameters shall be specifically designed.

Drees
CUSTOM HOMESSM

DREES CUSTOM HOMES L.P.
6225 STATE HIGHWAY 161, SUITE 400, IRVING, TX. 75038
(972) 953-4500
Copyright © 2018, (2016) The Drees Company. All Rights Reserved. No portion of this material may be reproduced in any form or by any means, including photocopying, without the express written permission of the Drees Company. The Drees Company will vigorously prosecute any unauthorized use of this material.

House:
BRYNLEE II

Series:

Plan No.:
2805

Std. Drawn By: STD_BY

Std. Chk. By: ARC

Std. Date: STD_DATE

Date of Last Rev: REV_DATE

Sheet Description:
FRONT AND REAR ELEVATIONS

SCALE: 1/8" = 1'-0"

Contract Drawn By: BRIAN W.

Phone #: N/A

Coordinator's Name: LISA C.

Coordinator's Phone #: 859 578-4322

VIR3-0018-11.dwg Jan 30, 2019 - 3:40pm

Original Site Specific Dwg. & Effective Change Order Date:
05/07/18

Subdivision:
Job #:
Customer Name:
Job Address:

VIRIDIAN
VIR3-0018-11
MODEL
4804 CYPRESS THORN DRIVE

Sheet No.
6.01